

ARCHITECTURAL DRAWINGS

0000 COVER SHEET

0000 EARLY WORKS

0101 SPECIFICATION NOTES & SCHEDULES
0201 SITE PLAN
0501 DEMOLITION PLANS
0502 DEMOLITION ELEVATIONS

1000 FLOOR PLANS

1001 FLOOR PLAN - GROUND
1002 ROOF PLAN

3000 CONCRETE

3001 CONCRETE PROFILE - GROUND

6000 ELEVATIONS

6001 ELEVATIONS - NORTH & EAST
6002 ELEVATIONS - SOUTH & WEST

6500 SECTIONS

6501 SECTIONS A & B
6502 SECTION C

7000 DETAILS

7001 DETAILS - SHEET 1

8000 INTERNALS

8001 WET AREA ELEVATIONS - SHEET 1

PROJECT

ST HELENS MEMORIAL PARK TOILET AMENITIES

ADDRESS 37-39 Cecilia St, St Helens TAS 7216

PROPERTY ID #####
TITLE REF #####
OWNER BREAK O'DAY COUNCIL

DESIGNER STUART TANNER
SITE AREA #####
FLOOR AREA #####
BUILDING CLASS 10a
BAL N/A
SITE CLASS #####
CLIMATE ZONE #####
WIND CLASS #####

CONSTRUCTION ISSUE

7/7/2026

CONSTRUCTION NOTES

- ALL LIGHTING, PLUMBING FIXTURES TO BE SUPPLIED BY BODC + INSTALLED & COMMISSIONED BY BUILDER/ELECTRICIAN/PLUMBER.
- ALLOW FOR INSTALL IN ALL SITUATIONS WHERE SUPPLIED BY OWNER/COUNCIL.
- JOINERY TO BE INCLUDED IN CONSTRUCTION CONTRACT
- CONFIRM MECH VENT SPECIFICATION WITH BUILDING SURVEYOR + NOMINATED INSTALLER

STEEL: ALL STEEL WORK EITHER HDG AS NOTED, OR GROUND TO REMOVE RUST, PRIMED AND PAINT GALVANISED WITH DULUX WEATHERMAX HBR SYSTEM: COLOUR GALV. TO AS/NZS 4600:2018 & NCC

TIMBER: ALL TIMBER STRUCTURAL FRAMING AND FIXINGS TO AS1684. STUD FRAMES ALL 140MM MGP10 UNLESS NOTED, MID RAIL NOGGINGS @ MAX 1500C-C.

EXTERIOR STUD WALLS: STEEL STUD FRAME TO AS/NZS 4600:2018 & NCC

INTERIOR LININGS: COMPRESSED FIBRE CEMENT & COMPACT LAMINATE SHEET, TO AS/NZS 2980.2 & NCC

WATERPROOFING: TO AS3740 & NCC, MEMBRANES INSTALLED BELOW FLOOR FINISHES AND BEHIND WALL FINISHES TO FORM IMPERVIOUS BARRIER.

WET AREA TILES: TO AS4586, AS4663 & NCC TO MINIMUM P4 SLIP RESISTANCE FOR COMMERCIAL

THERMAL PERFORMANCE:

ALL REASONABLE MEASURES ARE TO BE TAKEN BY BUILDER TO MAINTAIN AIR TIGHT BUILDING ENVELOPE FOR OPTIMAL THERMAL PERFORMANCE:

- TAPE ALL BUILDING MEMBRANE JOINS
- CONTINUOUS MASTIC OR FOAM SEAL AROUND WINDOW FRAMES AND DOORS TO MINIMISE DRAUGHTS
- CONTINUOUS MASTIC BEAD UNDER EXTERNAL WALL PLATES TO FLOOR JUNCTION
- ALL PENETRATIONS THROUGH EXTERNAL FABRIC TO BE TAPED AND OR SILICONE SEALED
- DRAUGHT + FIREPROOF SHROUD TO ALL RECESSED DOWNLIGHTS
- SELF CLOSING DAMPERS TO EXHAUST FANS

INSULATION:

FLOOR: EXISTING, DISCUSS WITH TILER

WALL: R3.8 BULK EXTERNAL. R4 SOUNDSREEN BULK TO INTERNAL WALLS WHERE APPROPRIATE

CEILING: OPEN TO FRAMING


GLAZING: N/A

SIGNAGE:

ALL SIGNAGE TO BE STAINLESS STEEL WITH BRAILLE IN ACCORDANCE WITH AS1428.1


- | | |
|-----|--|
| S01 | UNISEX TOILET RH |
| S02 | MALE TOILET & MALE AMBULANT TOILET |
| S03 | MALE AMBULANT TOILET |
| S04 | FEMALE TOILET & FEMALE AMBULANT TOILET |
| S05 | FEMALE AMBULANT TOILET |

FINISHES AND FIXTURES SCHEDULE					
CODE	DESCRIPTION	LOCATION	PRODUCT INFORMATION	SUPPLIER	IMAGE
EXTERIOR					
EF01	Blockwork (New & Existing)	Facade	Description: Paint Finish to Concrete Blockwork Range: Dulux Weathershield Top Coat Colour: Misty Moore Finish: Semi Gloss Code: 526A5	Dulux	
EF02	Wall Cladding	Facade	Description: CFC Cladding Cladding: Commercial Expresspanel Thickness: 9mm Finish: Paint Finish Range: Dulux Weathershield Colour/TBC Finish: Satin Code: TBC	Cemintel	
EF03	Batten Screening	Screens & Gates	Description: Timber Screening Battens: Silvertop Ash 80x55mm DAR Finish: 2x Coats Cutex CD-50 Oil Frame: 75x25mm RH5, Hot Dipped Galvanised Filing: Right Screw Countersunk Filing; Patched to conceal and match Timber	By Contractor	
EF04	Steelwork	Structure	Description: All Steelwork Finish: Hot Dip Galvanised	By Contractor	
RF01	Roof Sheet Cladding	Roof	Description: Roof Sheeting Range: Ampelite Wvegglas GC Finish: Opal Filing: To Manufacturers requirements Flashing & Gutter: Colorbond Gully	Ampelite	
INTERIOR					
IF01	Blockwork (New & Existing)	Interior Walls	Description: Paint Finish to Concrete Blockwork Range: Dulux Weathershield Top Coat Colour: Unforgettable (Hatt) Finish: Satin Code: 5N3H5	Dulux	
IF02	Wall Cladding	Interior Walls	Description: Paint Finish to Concrete Blockwork Range: Dulux Weathershield Top Coat Colour: Misty Moore Finish: Satin Code: 526A5	Dulux	
IF03	Wall Cladding	Interior Walls - Male Amenities	Description: Compact Laminate Finish Thickness: 13mm Colour: Blue California Code: 499	Alberti Laminati	
IF04	Wall Cladding	Interior Walls - Female Amenities	Description: Compact Laminate Finish Thickness: 13mm Colour: Azzuro Lago Code: 486	Alberti Laminati	
IF05	Wall Cladding	Interior Walls - DDA Amenities	Description: Compact Laminate Finish Thickness: 13mm Colour: Blue Amorgos Code: 484	Alberti Laminati	
TILO1	Floor Tile	Flooring	Description: Floor Tile Finish Thickness: TBC Colour: TBC Code: TBC Note: Allow \$40 /m2 supply		
FIXTURES					
BH1	Bench	Cleaners Storage	Description: Flat Bench Size: 1215(w) x 610(d) x 900mm(h) Material: 304 Stainless Steel Code: 2448 Note: Upgrade shelf to stainless steel and feet to screw down option	Brayco	
CS1	Cleaners Sink	Cleaners Storage	Description: Floor Mounted Cleaners Sink Size: 582(w) x 600(d) x 280mm(h) - 35L Material: 304 Stainless Steel Code: CSF Tapware: TW-SET-04	Britex	
GR1	Grabrail	DDA Amenities	Description: Backrest & Combination Rail Material: 304 Stainless Steel Code: BTK-6RC-640	Britex	
GR2	Grabrail	Ambulant Amenities	Description: 90° Ambulant Grab Rail Material: 304 Stainless Steel Code: BTK-01-050	Britex	
MP1	Utility Shelf	Cleaners Storage	Description: Utility Shelf with Mop & Rag Holder Size: 765(w) x 204mm(d) Material: 304 Stainless Steel Code: BTK-10-002	Britex	
MR1	Mirror	DDA Amenities	Description: Security Stainless Steel Mirror (accessible compliant) Size: 400(w) x 1000 mm(d) Material: 304 Stainless Steel Code: SMIR-10045-HF	Britex	
PT1	Toilet Partition	Male & Female Amenities	Description: Toilet & Change Cubicle System Thickness: 13mm Filing: Overhead Braaced Floor Mounted Colour: Storm Hardware: Black Code: DB-FM Note: ST1 - Provide Matching Compact laminate seat to each change cubicle	Polytec	
PT2	Urinal Partition	Male Amenities	Description: Urinal Division Rounded Thickness: 13mm Filing: Pedestal Mounted Colour: Storm Hardware: Black Code: UR-RO	Polytec	
TRH1	Toilet Roll Holder	Amenities	Description: Double Toilet Roll Holder Size: 260(w) x 110(d) x 30mm(d) Material: 304 Stainless Steel Code: BTK-06-051	Britex	
UR1	Urinal	Male Amenities	Description: Urinal Model: Regal Urinal Material: 304 Stainless Steel Code: UR Note: Non Flushing Model - Client to confirm	Britex	
WB1	Wash Basin	External Entry	Description: Vanity Inset Hand Basin Size: 500(w) x 450(d) x 160mm(h) Material: 304 Stainless Steel Code: HBV Tapware: TW-9101 Note: Fully weld into 304 stainless benchtop	Britex	
WB2	Wash Basin	DDA Amenities	Description: Accessible Bellagio Basin Right Hand Size: 600(w) x 450(d) x 130mm(h) Material: 304 Stainless Steel Code: HBRL-DSR Tapware: TW-9108 Note: Provide AS1428.1 compliant bottle trap	Britex	
WC1	Toilet	Male & Female Amenities	Description: Wall Mounted Pan Size: 350(w) x 610 (d) x 350mm(h) Material: 304 Stainless Steel Code: PWM Toilet Seat: SVRC-B Note: Install to AS1428.1 requirements in Ambulant facilities	Britex	
WC2	Toilet	DDA Amenities	Description: Centurion Accessible Pan Size: 350(w) x 800 (d) x 470mm(h) Material: 304 Stainless Steel Code: PWM Toilet Seat: SVRC-B Note: Install to AS1428.1 requirements	Britex	

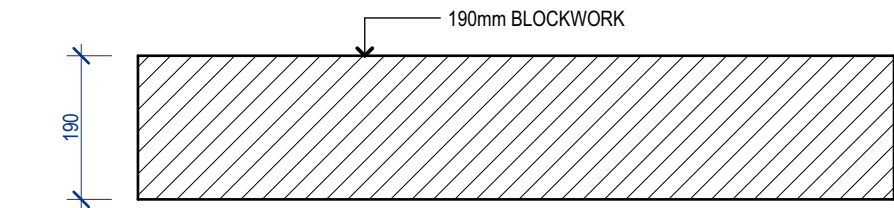


BW01

LOCATION: EXTERNAL WALLS
COMMENTS: UNREINFORCED TO MATCH EXISTING WITH BOND BEAM TO TOP COURSING

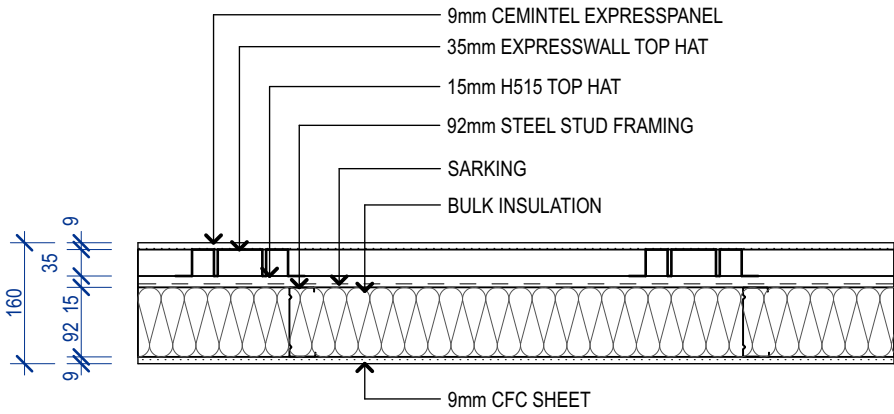

EW01

LOCATION: EXTERNAL WALLS
COMMENTS: LOCATED ABOVE BLOCKWORK DATUM

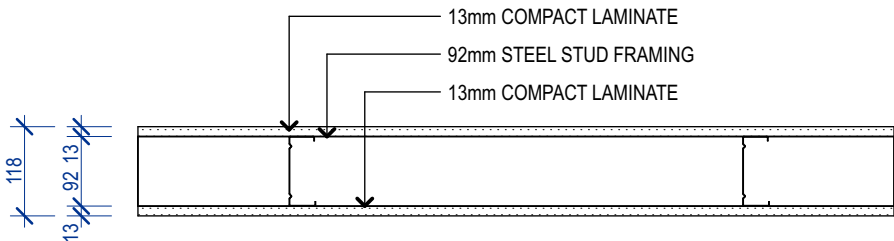


P02

LOCATION: INTERNAL WALLS
COMMENTS: LOCATED ABOVE BLOCKWORK DATUM




WALL LEGEND

1:10

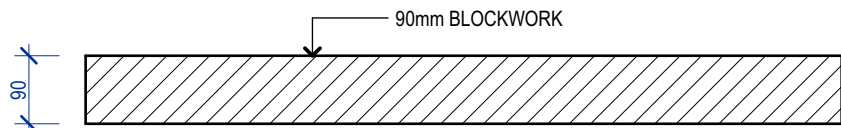


BW02

LOCATION: INTERNAL WALLS
COMMENTS: UNREINFORCED TO MATCH EXISTING WITH BOND BEAM TO TOP COURSING

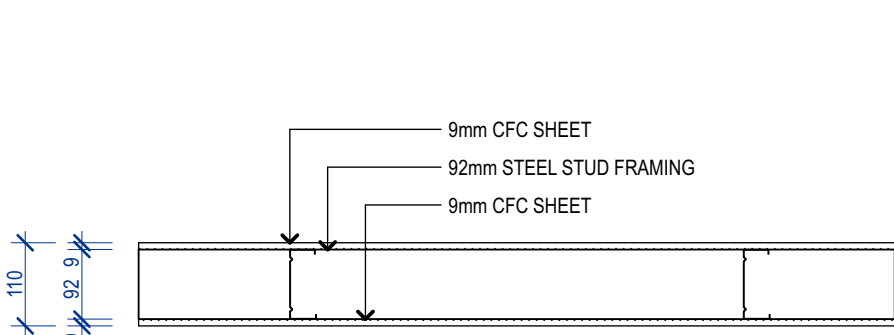


P01

LOCATION: INTERNAL WALLS
COMMENTS: LOCATED ABOVE BLOCKWORK DATUM

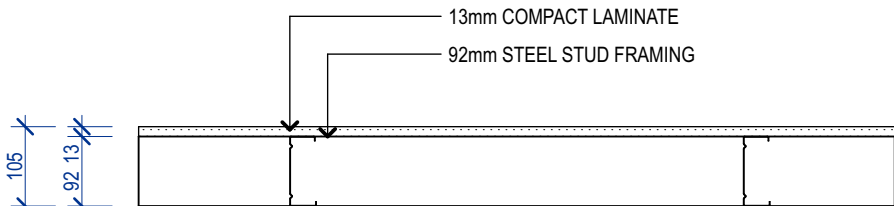

P03

LOCATION: INTERNAL WALLS
COMMENTS: LOCATED BEHIND WC'S

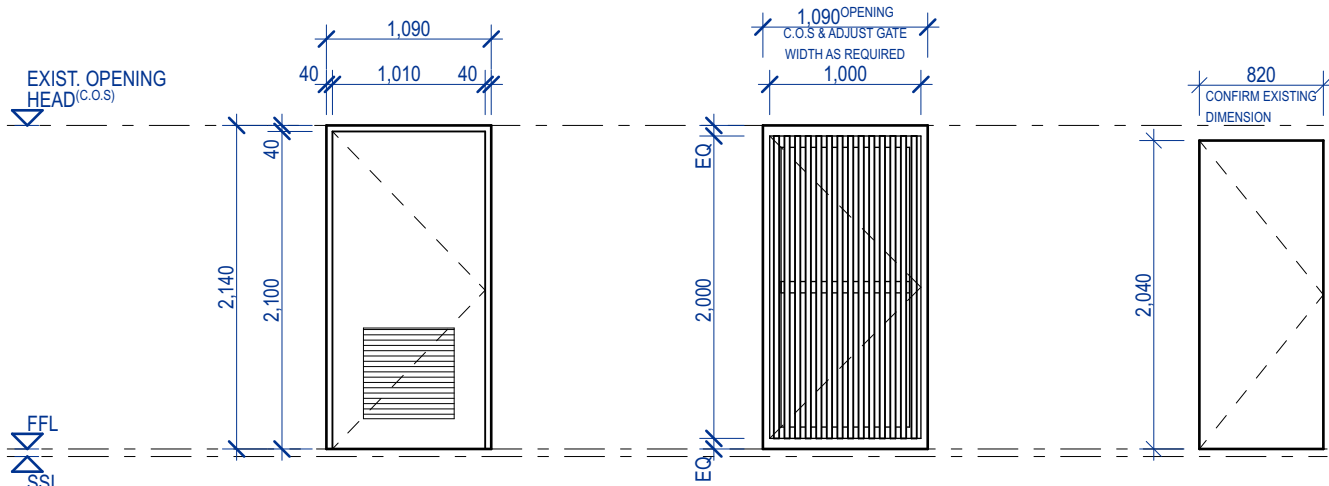

DOOR/ GATE NUMBER:	D01	G01, G02 & G03 (SEE PLAN FOR SWING DIRECTION)	G04 (SEE PLAN FOR SWING DIRECTION)
DOOR LEAF:	38mm EXTERIOR GRADE SOLID CORE.	90x35 DAR SILVERTOP ASH BATTEN	35mm INTERIOR GRADE SOLID CORE.
DOOR LEAF FINISH:	VENEER FINISH TO MATCH EF03	EF03	PAINT FINISH EXTERNAL GRADE WEATHERMAX COLOUR TBC
FRAME:	PRESSED METAL.	75X25 RHS	METAL DOOR JAMB /BUILDER TO ADJUST
FRAME FINISH:	PAINT FINISH TO MATCH EF01	EF04	PAINT FINISH EXTERNAL GRADE WEATHERMAX COLOUR TBC
CLOSER:	YES	NO	NO
AS1428.1 COMPLIANT:	YES	NO	NO
NOTES:	600x600 GRILLE FOR FRESH AIR COMPLIANCE TO ROOM ENSURE 30% LUMINANCE CONTRAST	PROVIDE HDG SLOTTED 100 EA FOR GATE TO BE LOCKED INTO OPEN POSITION	CHECK EXISTING DOOR DIMENSION TO MATCH

DOOR & GATE SCHEDULE

1:50

TANNER ARCHITECTS™

03 6224 4377

mail@tanner-architects.com.au

Accreditation: 329877575

Issue ID	Issue Name	Issue Date
A	PRELIMINARY ISSUE	2/4/2026
B	BUILDING APPROVAL ISSUE	10/4/2026
01	CONSTRUCTION ISSUE	20/4/2026

Drawings to be read in conjunction with specification by TA and all drawings and documents by engineers and subconsultants referred to in these plans. Contractors are to verify all dimensions on site before commencing any work or producing shop drawings. Larger scale drawings and written dimensions take preference. Do not scale from drawings. These drawings are protected by the laws of copyright and may not be copied or reproduced without the written permission of TA. all discrepancies to be brought to the attention of the author. All building levels to AHD unless otherwise noted.

FOR CONSTRUCTION -
REV A

ST HELENS MEMORIAL PARK
TOILET AMENITIES

Client: ST HELENS BREAK O'DAY COUNCIL
Project Address: 39 CECILIA ST,
ST HELENS,
TAS 7216

EARLY WORKS -
SPECIFICATION NOTES & SCHEDULES

Scale: 1:10, 1:50 @ A2
Status: FOR CONSTRUCTION
Checked By: STA
Date: 7/7/2026

0101
01



Issue ID	Issue Name	Issue Date
A	PRELIMINARY ISSUE	24/2/2026
B	BUILDING APPROVAL ISSUE	10/4/2026
01	CONSTRUCTION ISSUE	20/4/2026


Drawings to be read in conjunction with specification by TA and all drawings and documents by engineers and subconsultants referred to in these plans. Contractors are to verify all dimensions on site before commencing any work or producing shop drawings. Larger scale drawings and written dimensions take preference. Do not scale from drawings. These drawings are protected by the laws of copyright and may not be copied or reproduced without the written permission of TA. All discrepancies to be brought to the attention of the author. All building levels to AHD unless otherwise noted.


FOR CONSTRUCTION-
REV A

Project Name
ST HELENS MEMORIAL PARK
TOILET AMENITIES
Client
ST HELENS BREAK 'O'DAY COUNCIL
Project Address
39 CECILIA ST,
ST HELENS,
TAS 7216

EARLY WORKS -
SITE PLAN
Scale: 1:100 @ A2
Status: FOR CONSTRUCTION
Checked By: STA
Date: 7/7/2026

0201
01

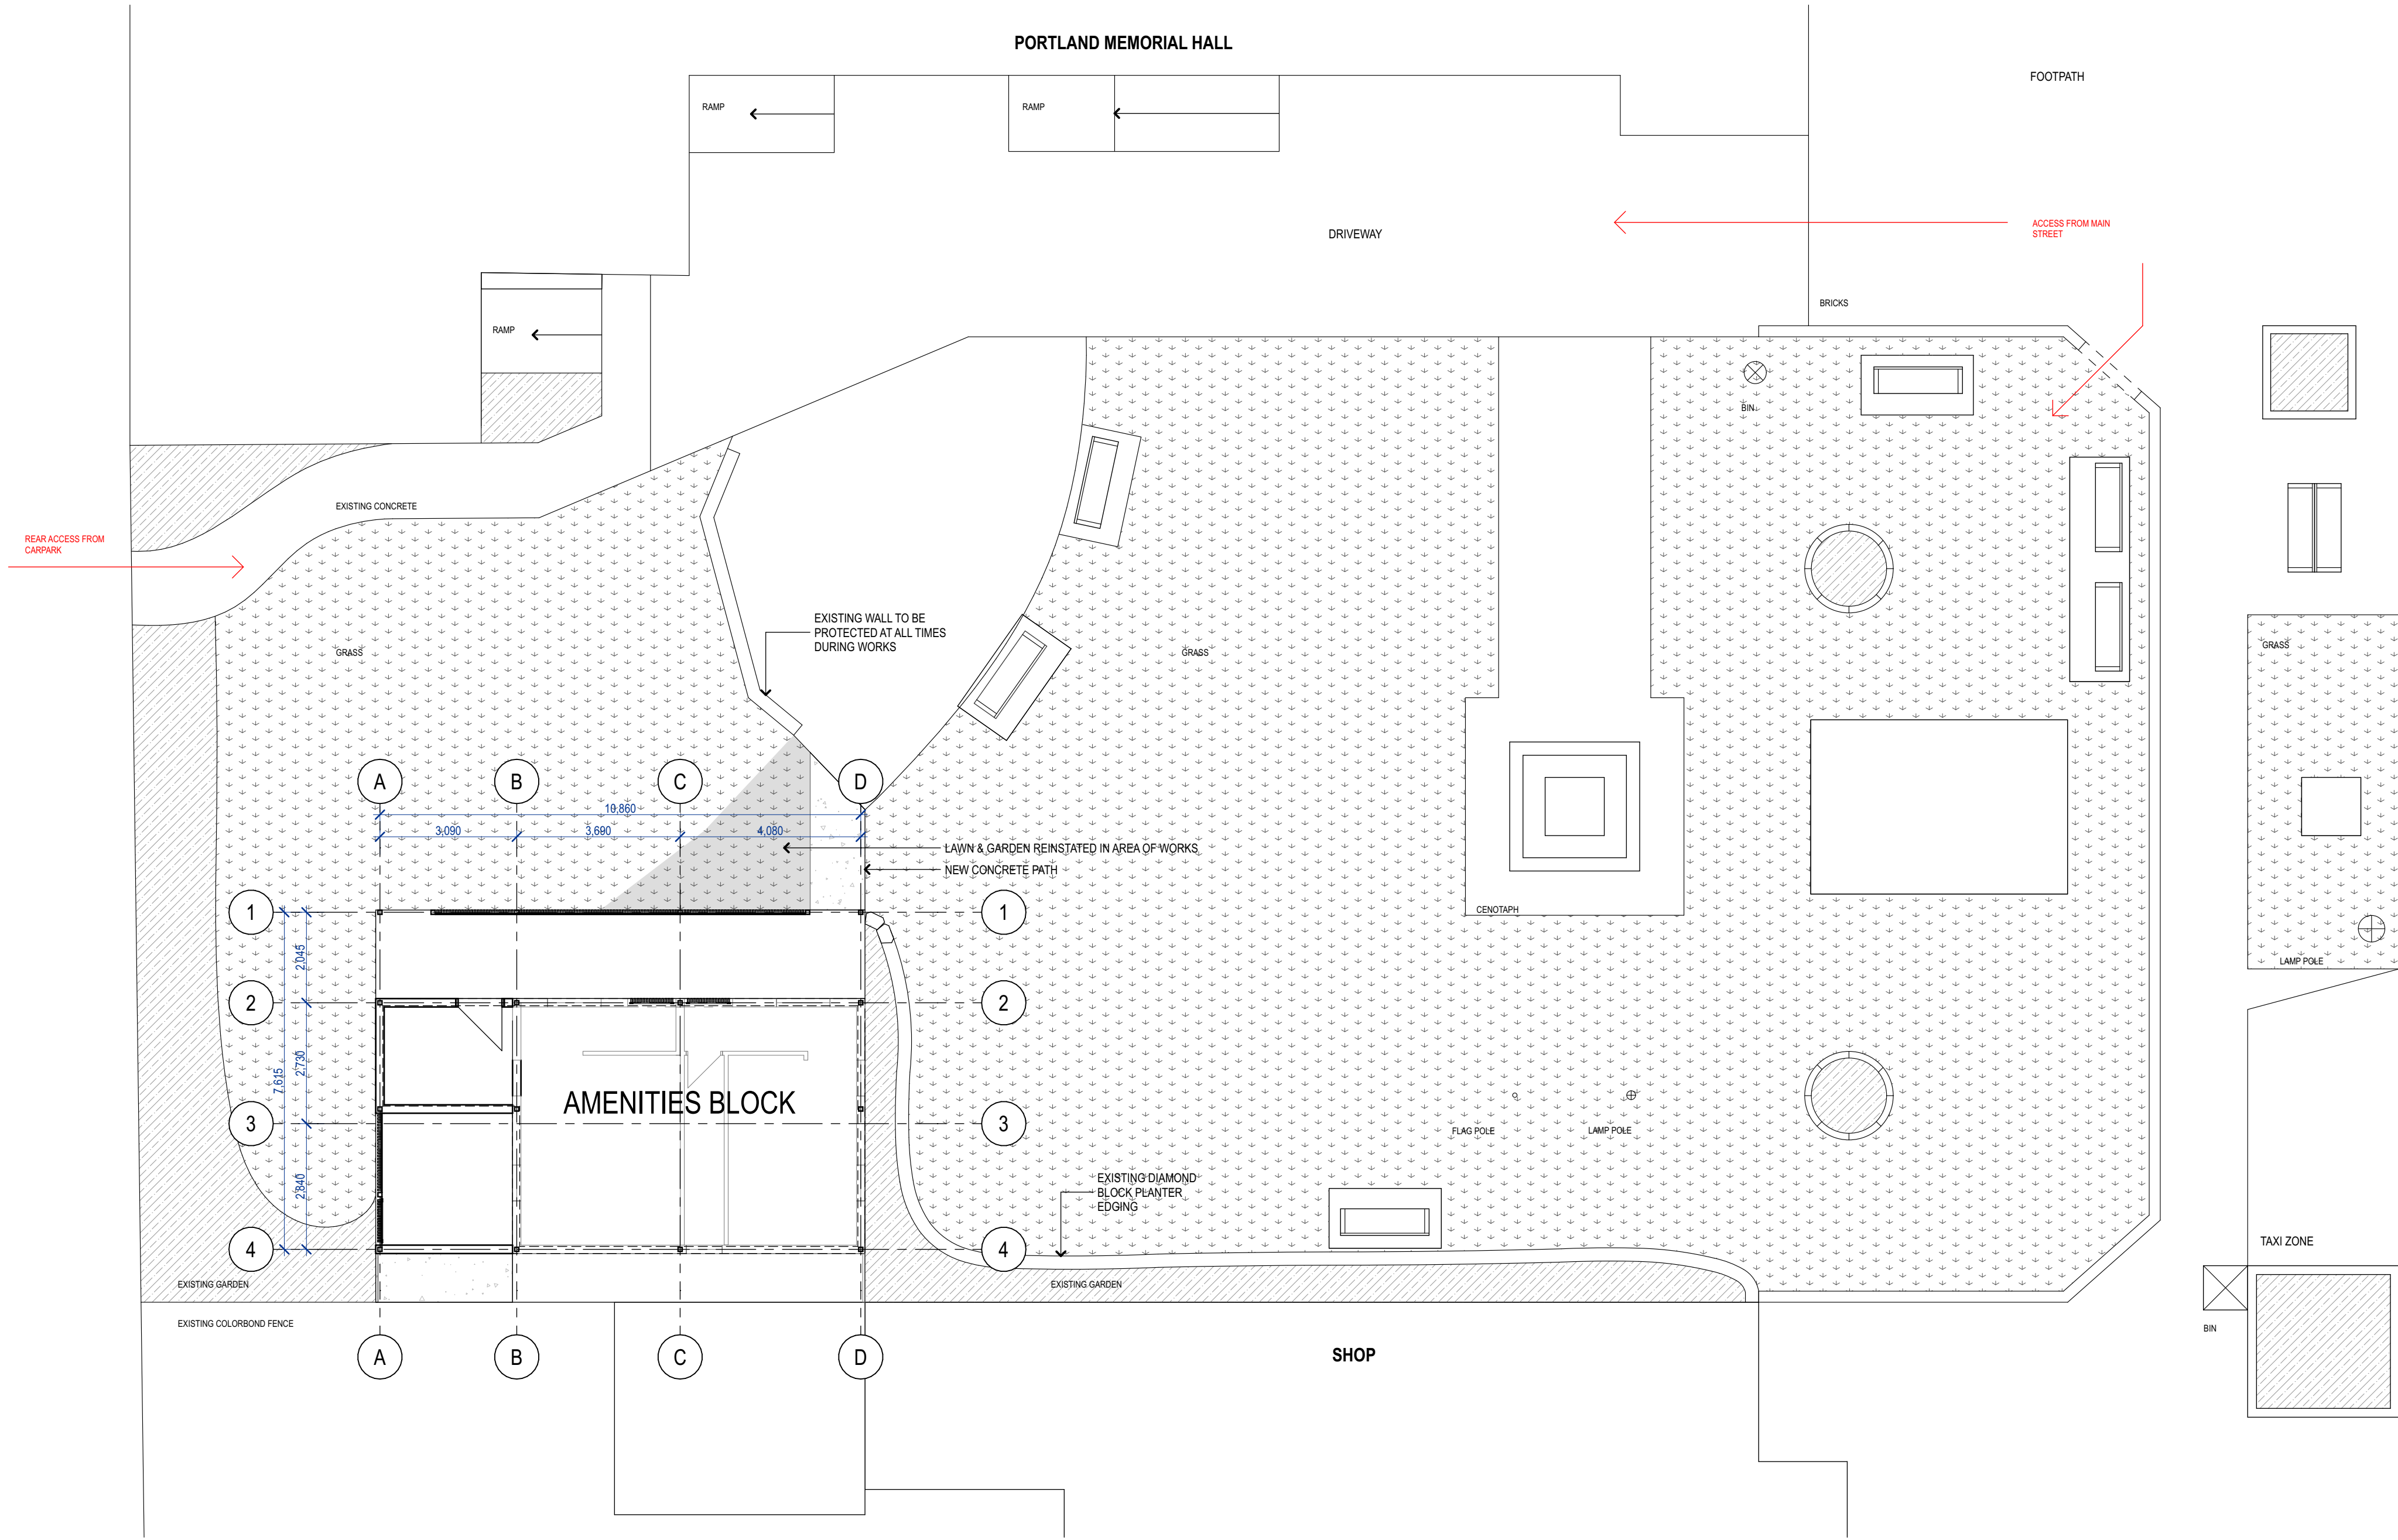

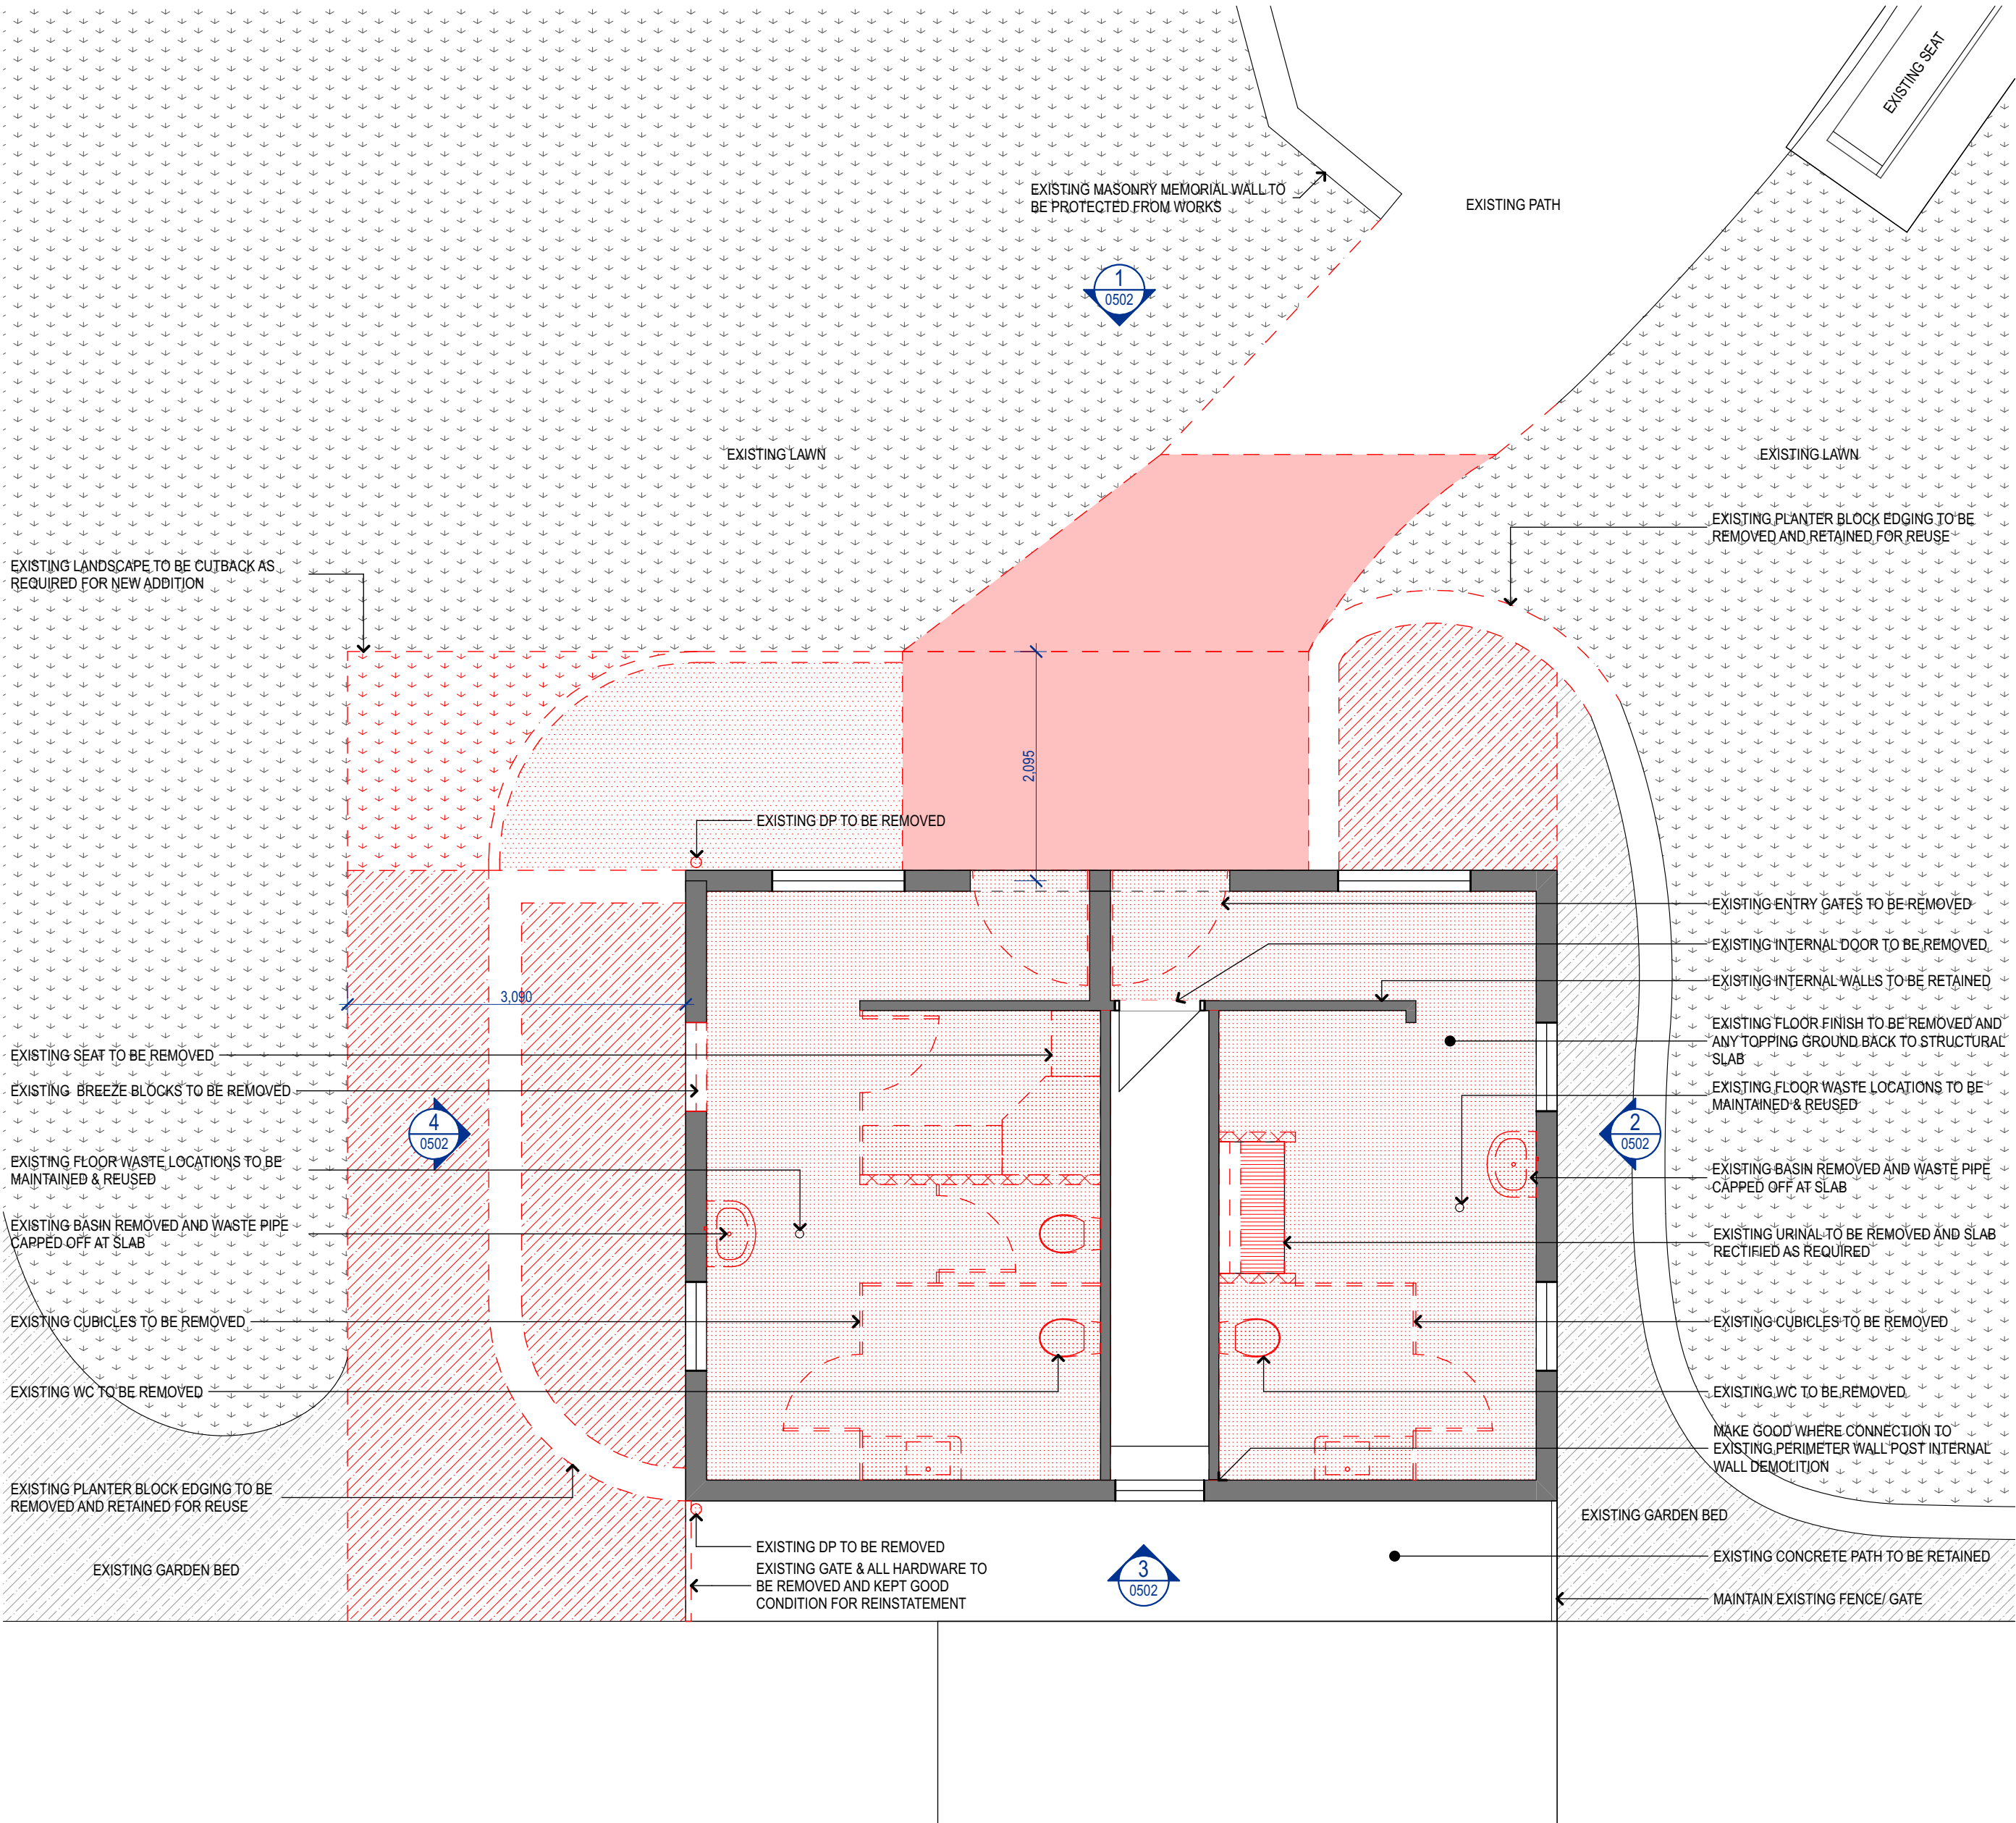


1
-
1:50

DEMOLITION PLAN - GROUND FLOOR

2
-
1:50

DEMOLITION PLAN - ROOF

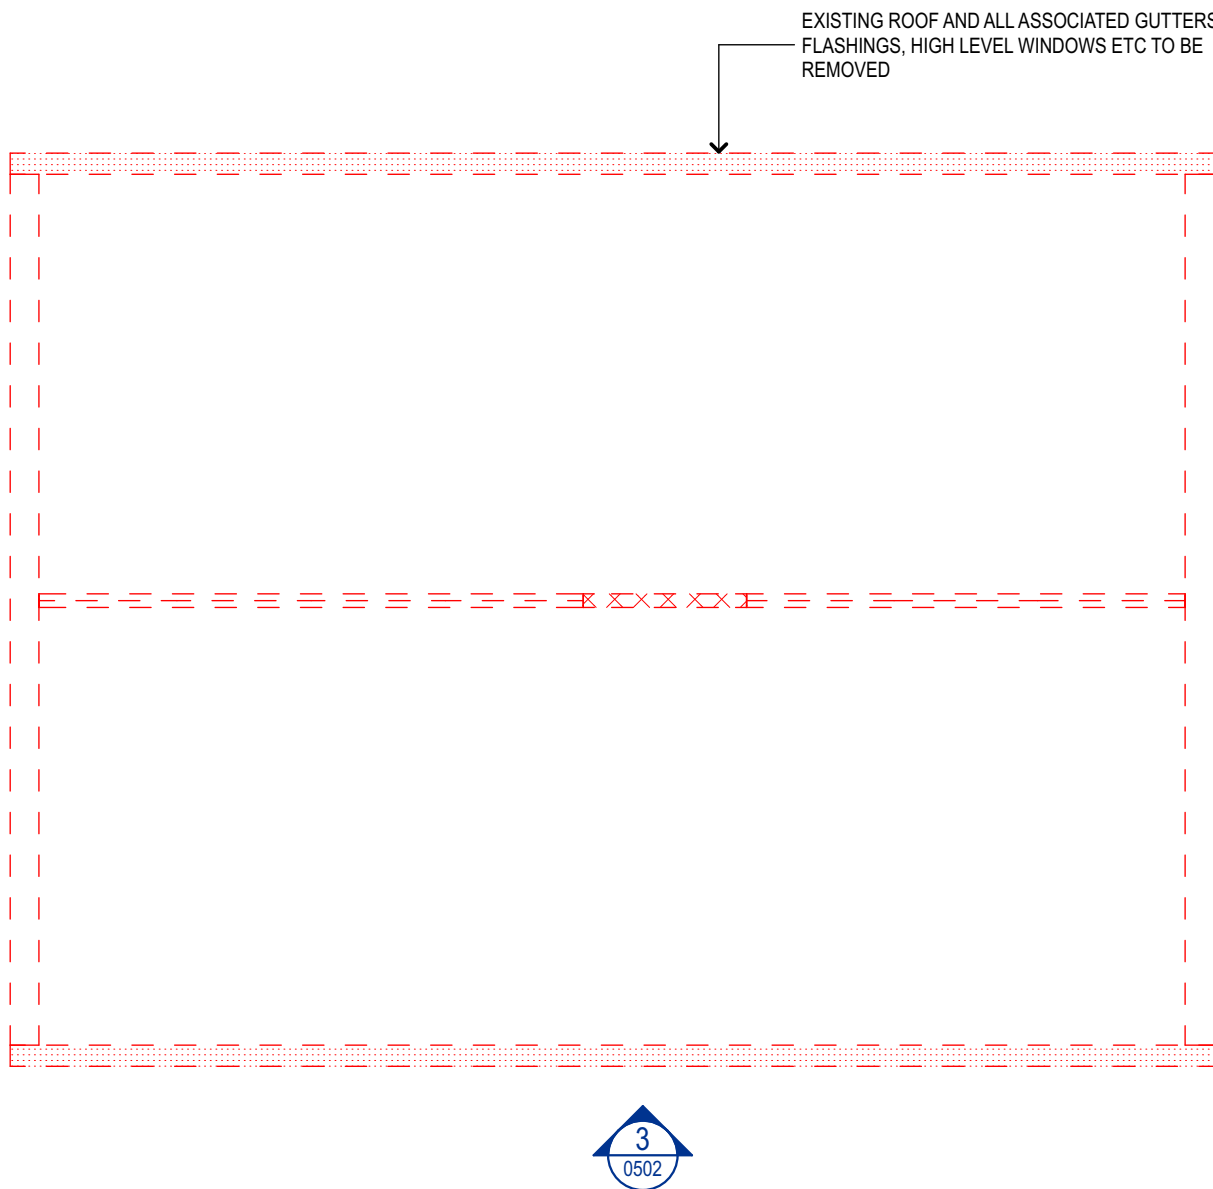

Issue ID	Issue Name	Issue Date
A	PRELIMINARY ISSUE	24/2/2026
B	BUILDING APPROVAL ISSUE	10/4/2026
01	CONSTRUCTION ISSUE	20/4/2026


Drawings to be read in conjunction with specification by TA and all drawings and documents by engineers and subconsultants referred to in these plans. Contractors are to verify all dimensions on site before commencing any work or producing shop drawings. Larger scale drawings and written dimensions take preference. Do not scale from drawings. These drawings are protected by the laws of copyright and may not be copied or reproduced without the written permission of TA. all discrepancies to be brought to the attention of the author. All building levels to AHD unless otherwise noted.

FOR CONSTRUCTION-
REV A


Project Name
ST HELENS MEMORIAL PARK
TOILET AMENITIES
Client
ST HELENS BREAK O'DAY COUNCIL
Project Address
39 CECILIA ST,
ST HELENS,
TAS 7216

EARLY WORKS -
DEMOLITION PLANS
Scale: 1:50 @ A2
Status: FOR CONSTRUCTION
Checked By: STA
Date: 7/7/2026


0501
01

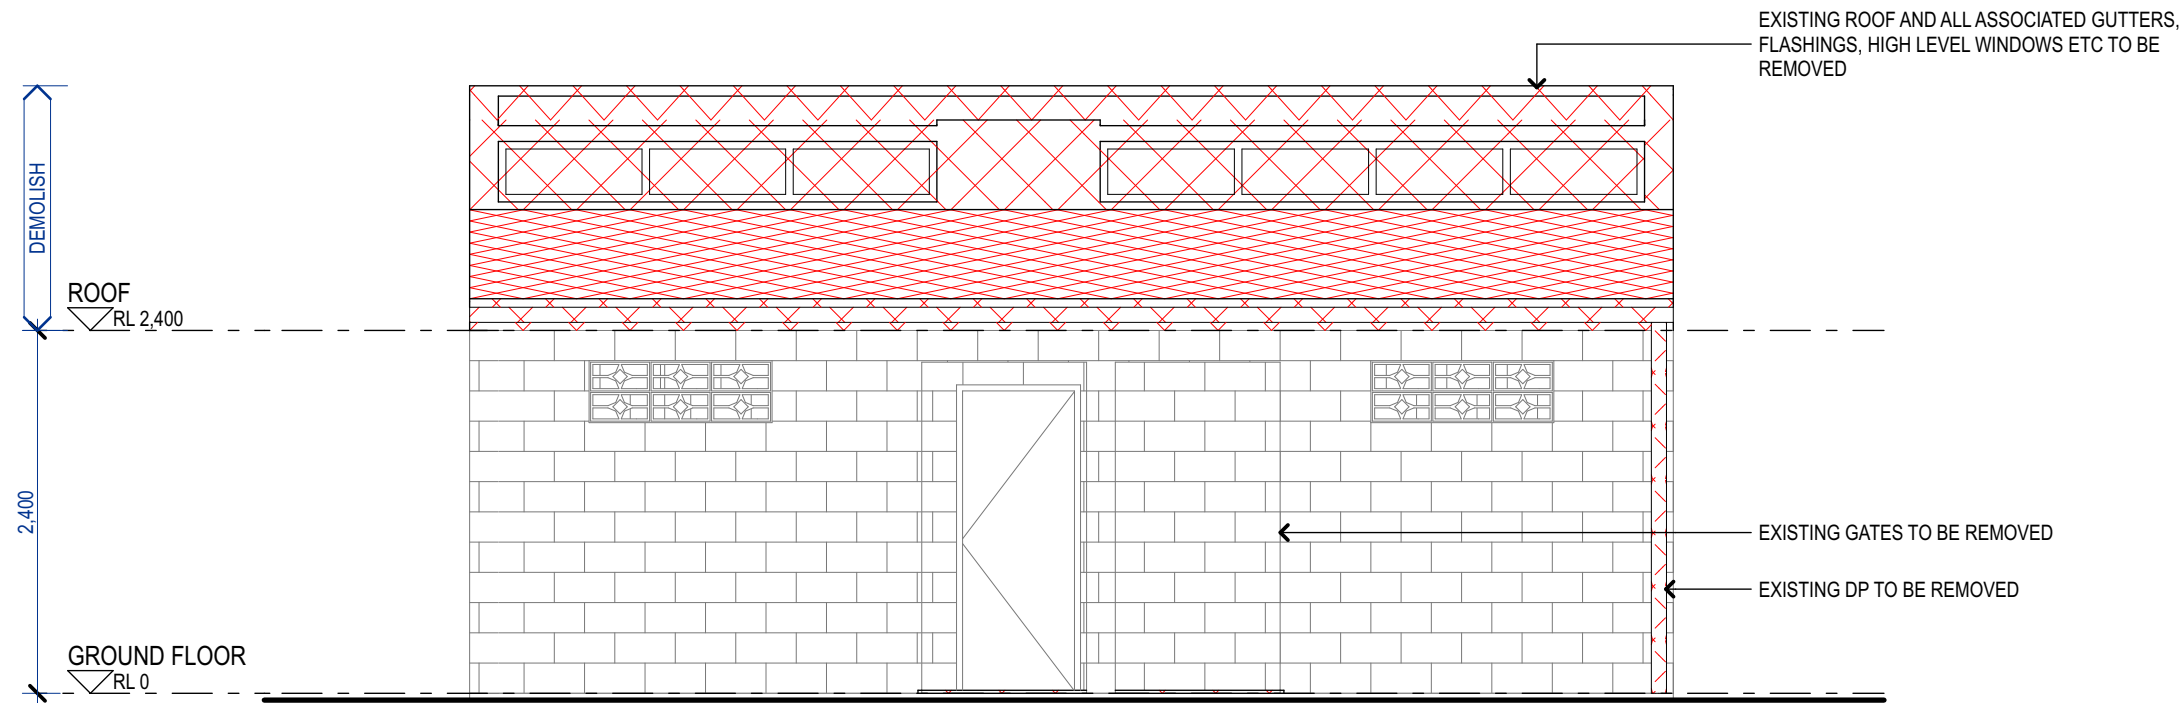


1 DEMOLITION - NORTH ELEVATION
1:50

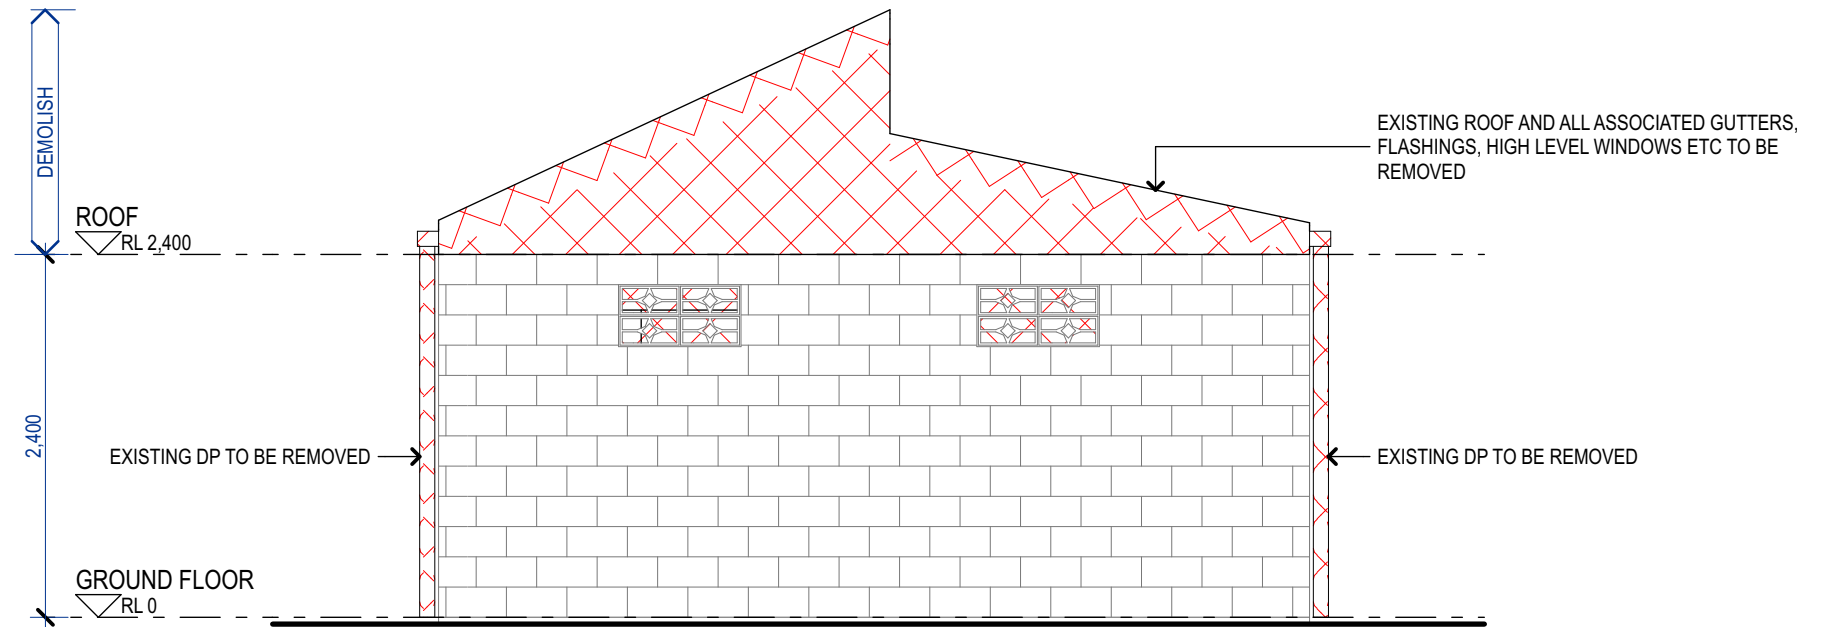


2 DEMOLITION - EAST ELEVATION
1:50

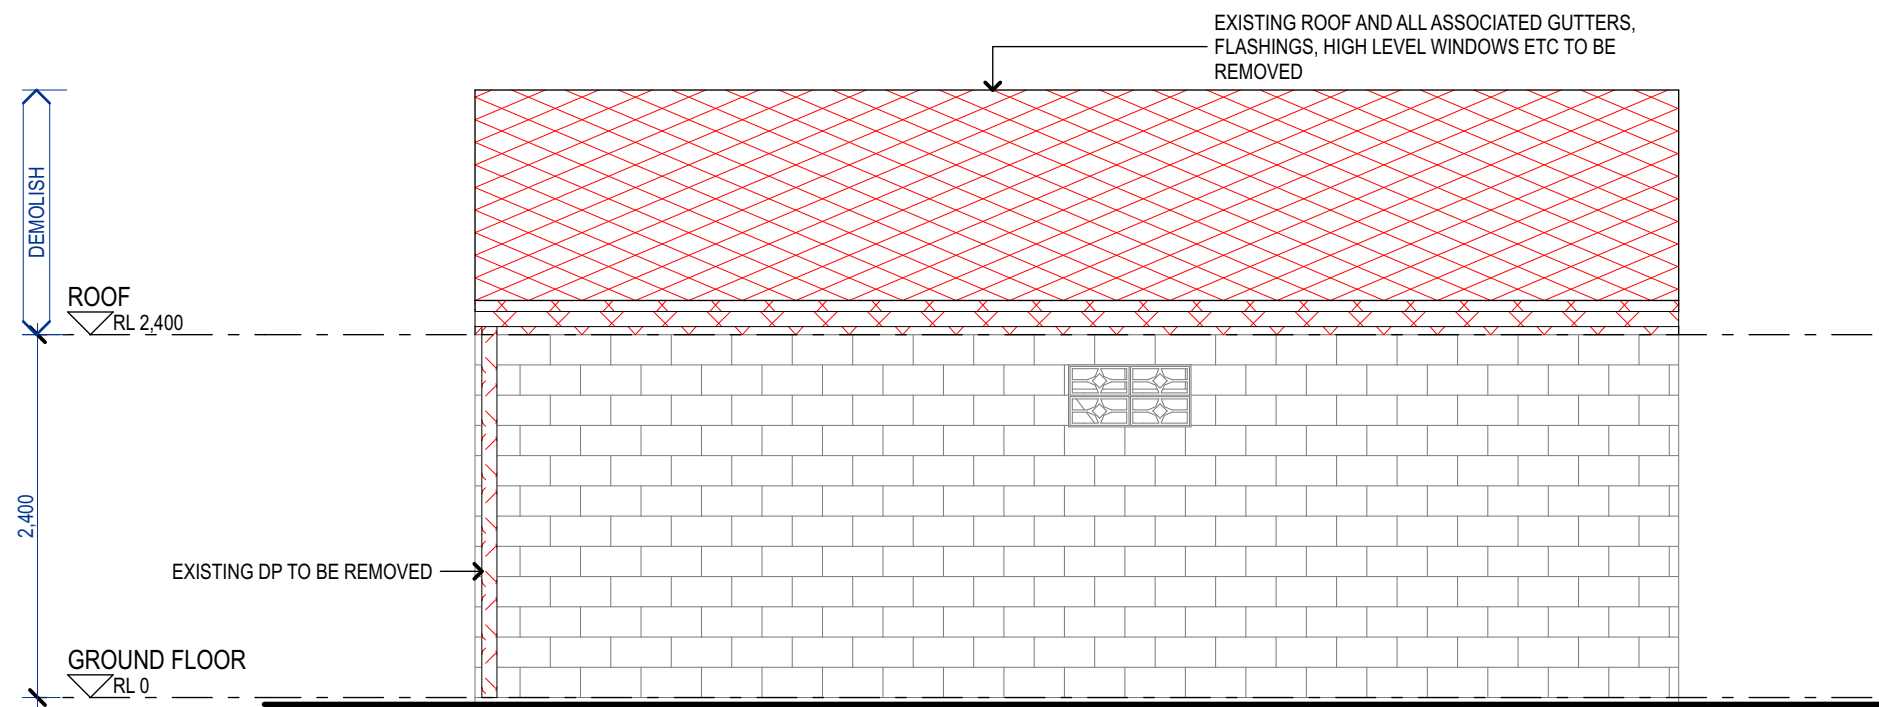

3 DEMOLITION - SOUTH ELEVATION
1:50

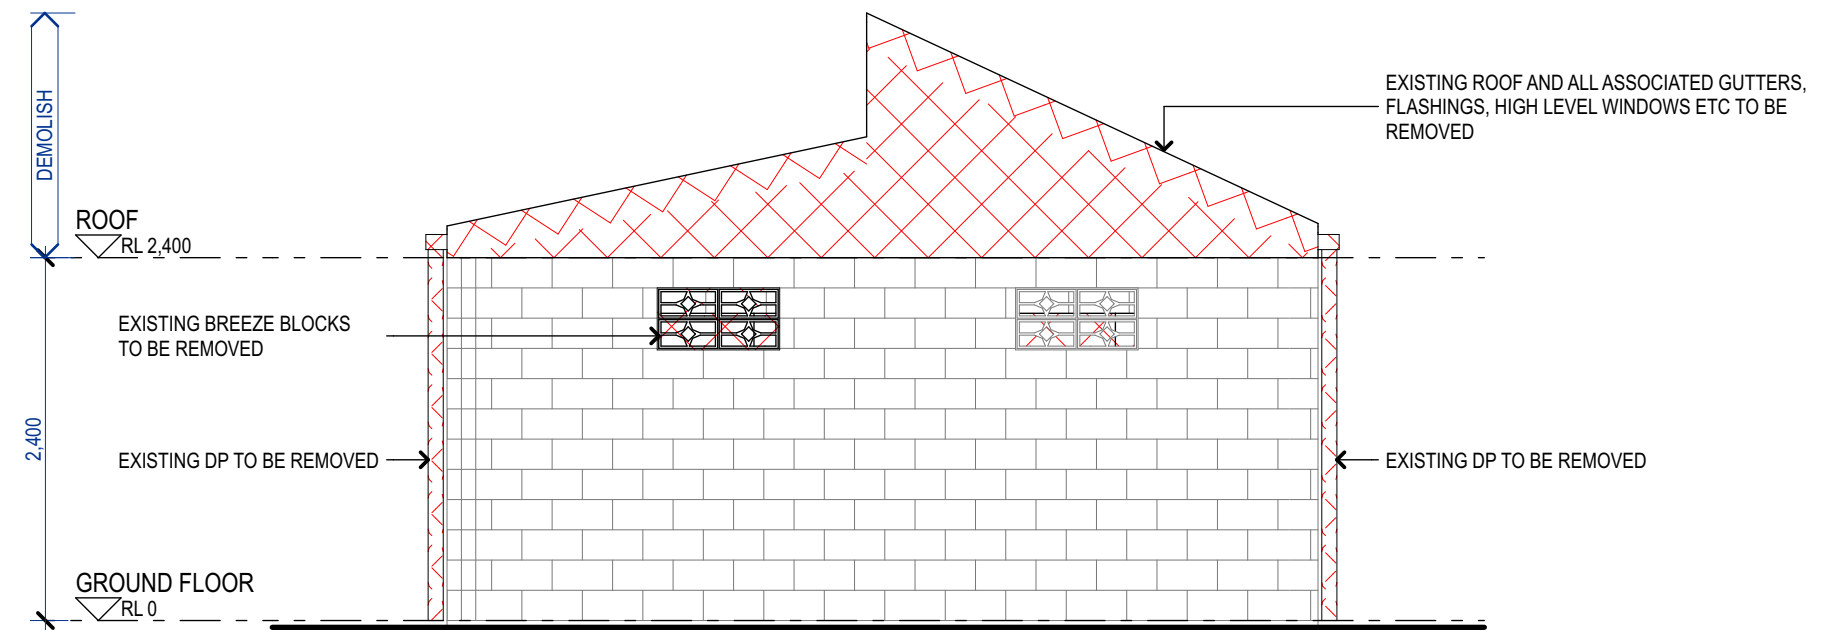

4 DEMOLITION - WEST ELEVATION
1:50

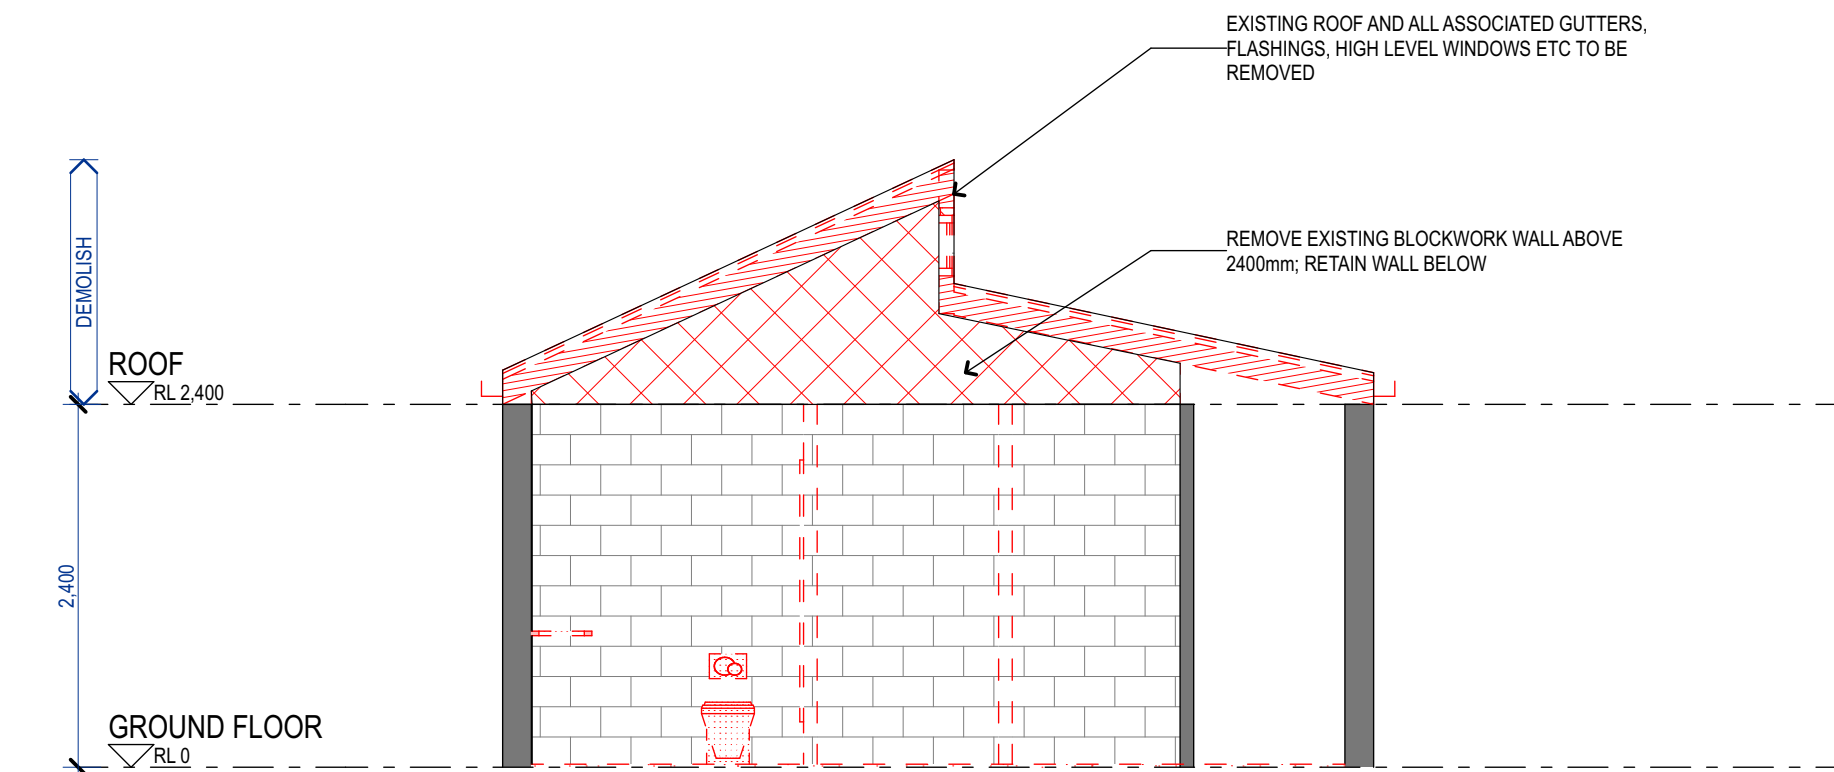

5 DEMOLITION - INTERNAL ELEVATION (1)
1:50

Issue ID	Issue Name	Issue Date
A	PRELIMINARY ISSUE	24/2/2026
B	BUILDING APPROVAL ISSUE	10/4/2026
01	CONSTRUCTION ISSUE	20/4/2026



Issue ID	Issue Name	Issue Date
A	PRELIMINARY ISSUE	24/2/2026
B	BUILDING APPROVAL ISSUE	10/4/2026
G1	CONSTRUCTION ISSUE	20/4/2026

Drawings to be read in conjunction with specification by TA and all drawings and documents by engineers and subconsultants referred to in these plans. Contractors are to verify all dimensions on site before commencing any work or producing shop drawings. Larger scale drawings and written dimensions take preference. Do not scale from drawings. These drawings are protected by the laws of copyright and may not be copied or reproduced without the written permission of TA. All discrepancies to be brought to the attention of the author. All building levels to AHD unless otherwise noted.


FOR CONSTRUCTION-
REV A

ST HELENS MEMORIAL PARK
TOILET AMENITIES
Client
ST HELENS BREAK 'O'DAY COUNCIL
Project Address
39 CECILIA ST,
ST HELENS,
TAS 7216

FLOOR PLANS -
FLOOR PLAN - GROUND

Scale: 1:50, 1:1 @ A2
Status: FOR CONSTRUCTION
Checked By: STA
Date: 7/7/2026

1001
01

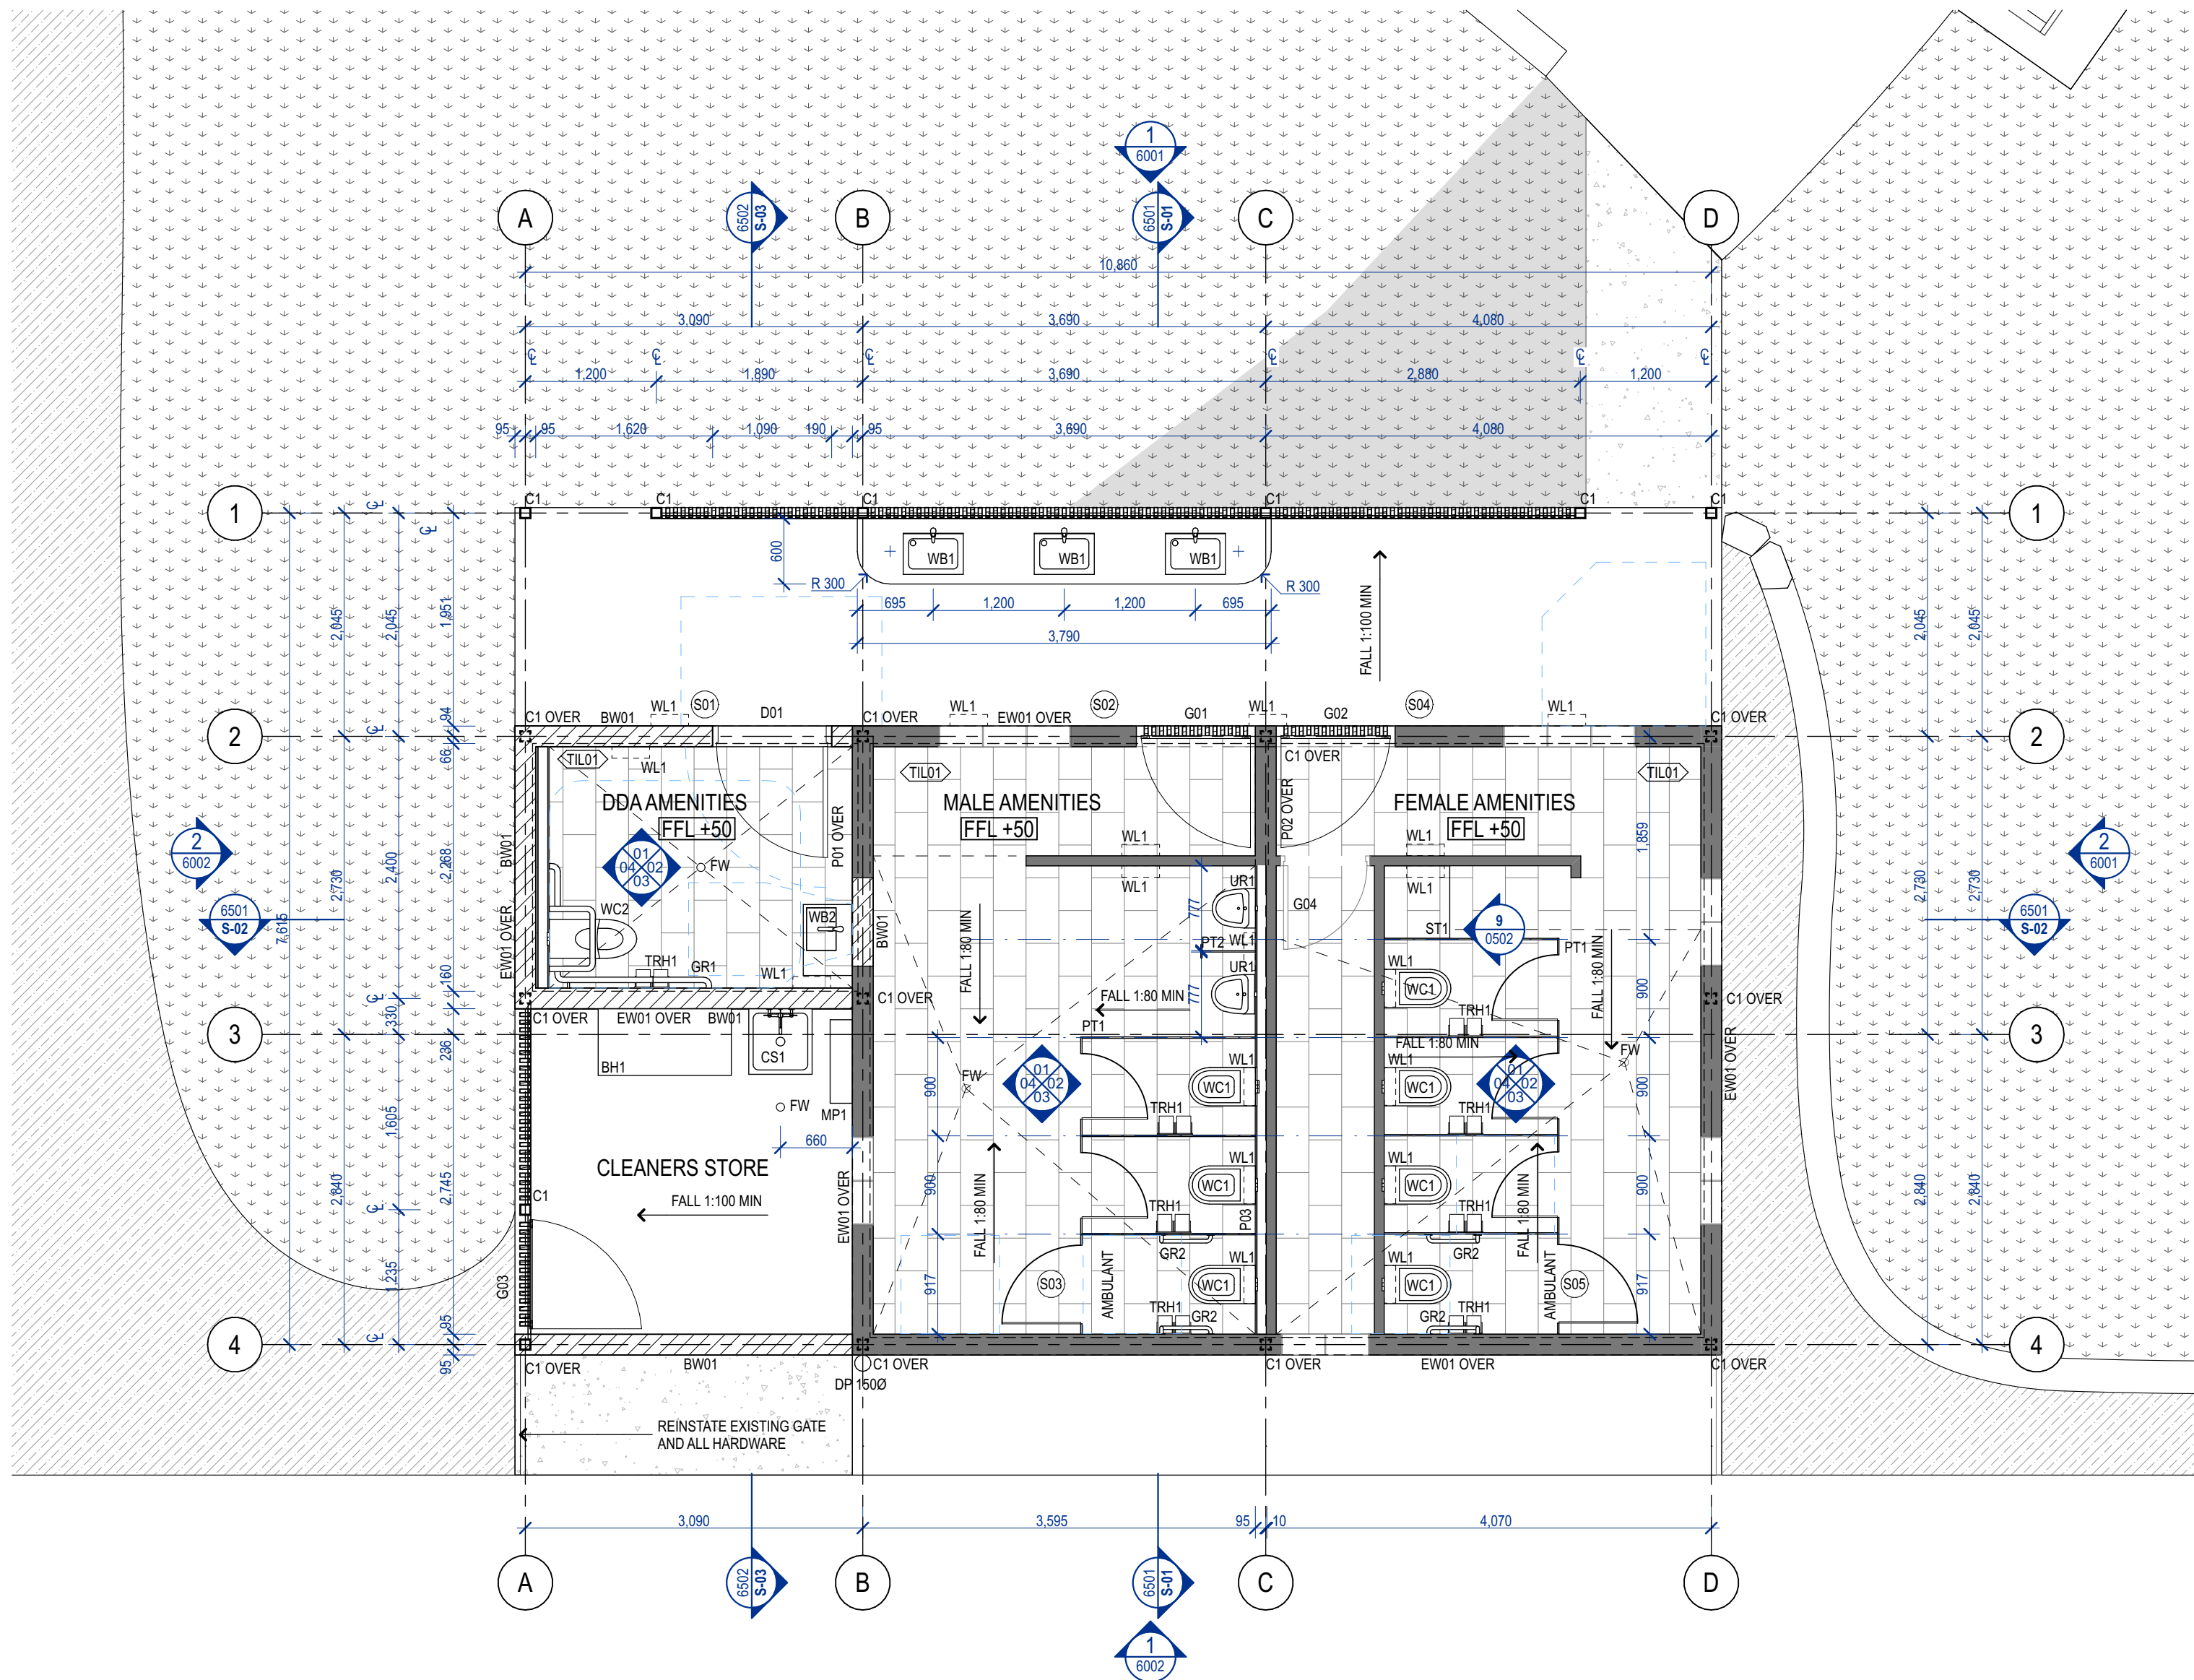

STRUCTURAL MEMBER SIZES:

- 100 100 SLAB ON GRADE
SL82(T), 30 COVER, N25 CONC
0.2 FORTECON
20MM MAX BEDDED SAND
100MM MIN COMPACTED FCR
- BP1 450Ø MASS CONCRETE BORED PIER TO ROCK.
150X10 CAST IN PLATE HDG (TYP)
- SF1 450w x 400d STRIP FOOTING
4-11TM(T&B), 50 COVER
- B1 200x100x4 RHS, SITE WELD TO C1. DULUX
METALSHIELD ZINC GALV SPRAY SITE WELDS
- B2 100x4 SHS, SITE WELD TO B1. DULUX
METALSHIELD ZINC GALV SPRAY SITE WELDS
- C1 100x4 SHS, SITE WELD TO CAST IN PLATE. DULUX
METALSHIELD ZINC GALV SPRAY SITE WELDS
- C1 OVER 100x4 SHS, 150x10 WITH CAST IN PLATE
LOCALLY CORE FILL BLOCKWORK UNDER




Issue ID	Issue Name	Issue Date
A	PRELIMINARY ISSUE	24/2/2026
B	BUILDING APPROVAL ISSUE	10/4/2026
01	CONSTRUCTION ISSUE	20/4/2026

Drawings to be read in conjunction with specification by TA and all drawings and documents by engineers and subconsultants referred to in these plans. Contractors are to verify all dimensions on site before commencing any work or producing shop drawings. Larger scale drawings and written dimensions take preference. Do not scale from drawings. These drawings are protected by the laws of copyright and may not be copied or reproduced without the written permission of TA. All discrepancies to be brought to the attention of the author. All building levels to AHD unless otherwise noted.

FOR CONSTRUCTION-
REV A

Project Name
ST HELENS MEMORIAL PARK
TOILET AMENITIES
Client
ST HELENS BREAK O'DAY COUNCIL
Project Address
39 CECILIA ST,
ST HELENS,
TAS 7216

FLOOR PLANS -
ROOF PLAN
Scale: 1:50, 1:1 @ A2
Status: FOR CONSTRUCTION
Checked By: STA
Date: 7/7/2026

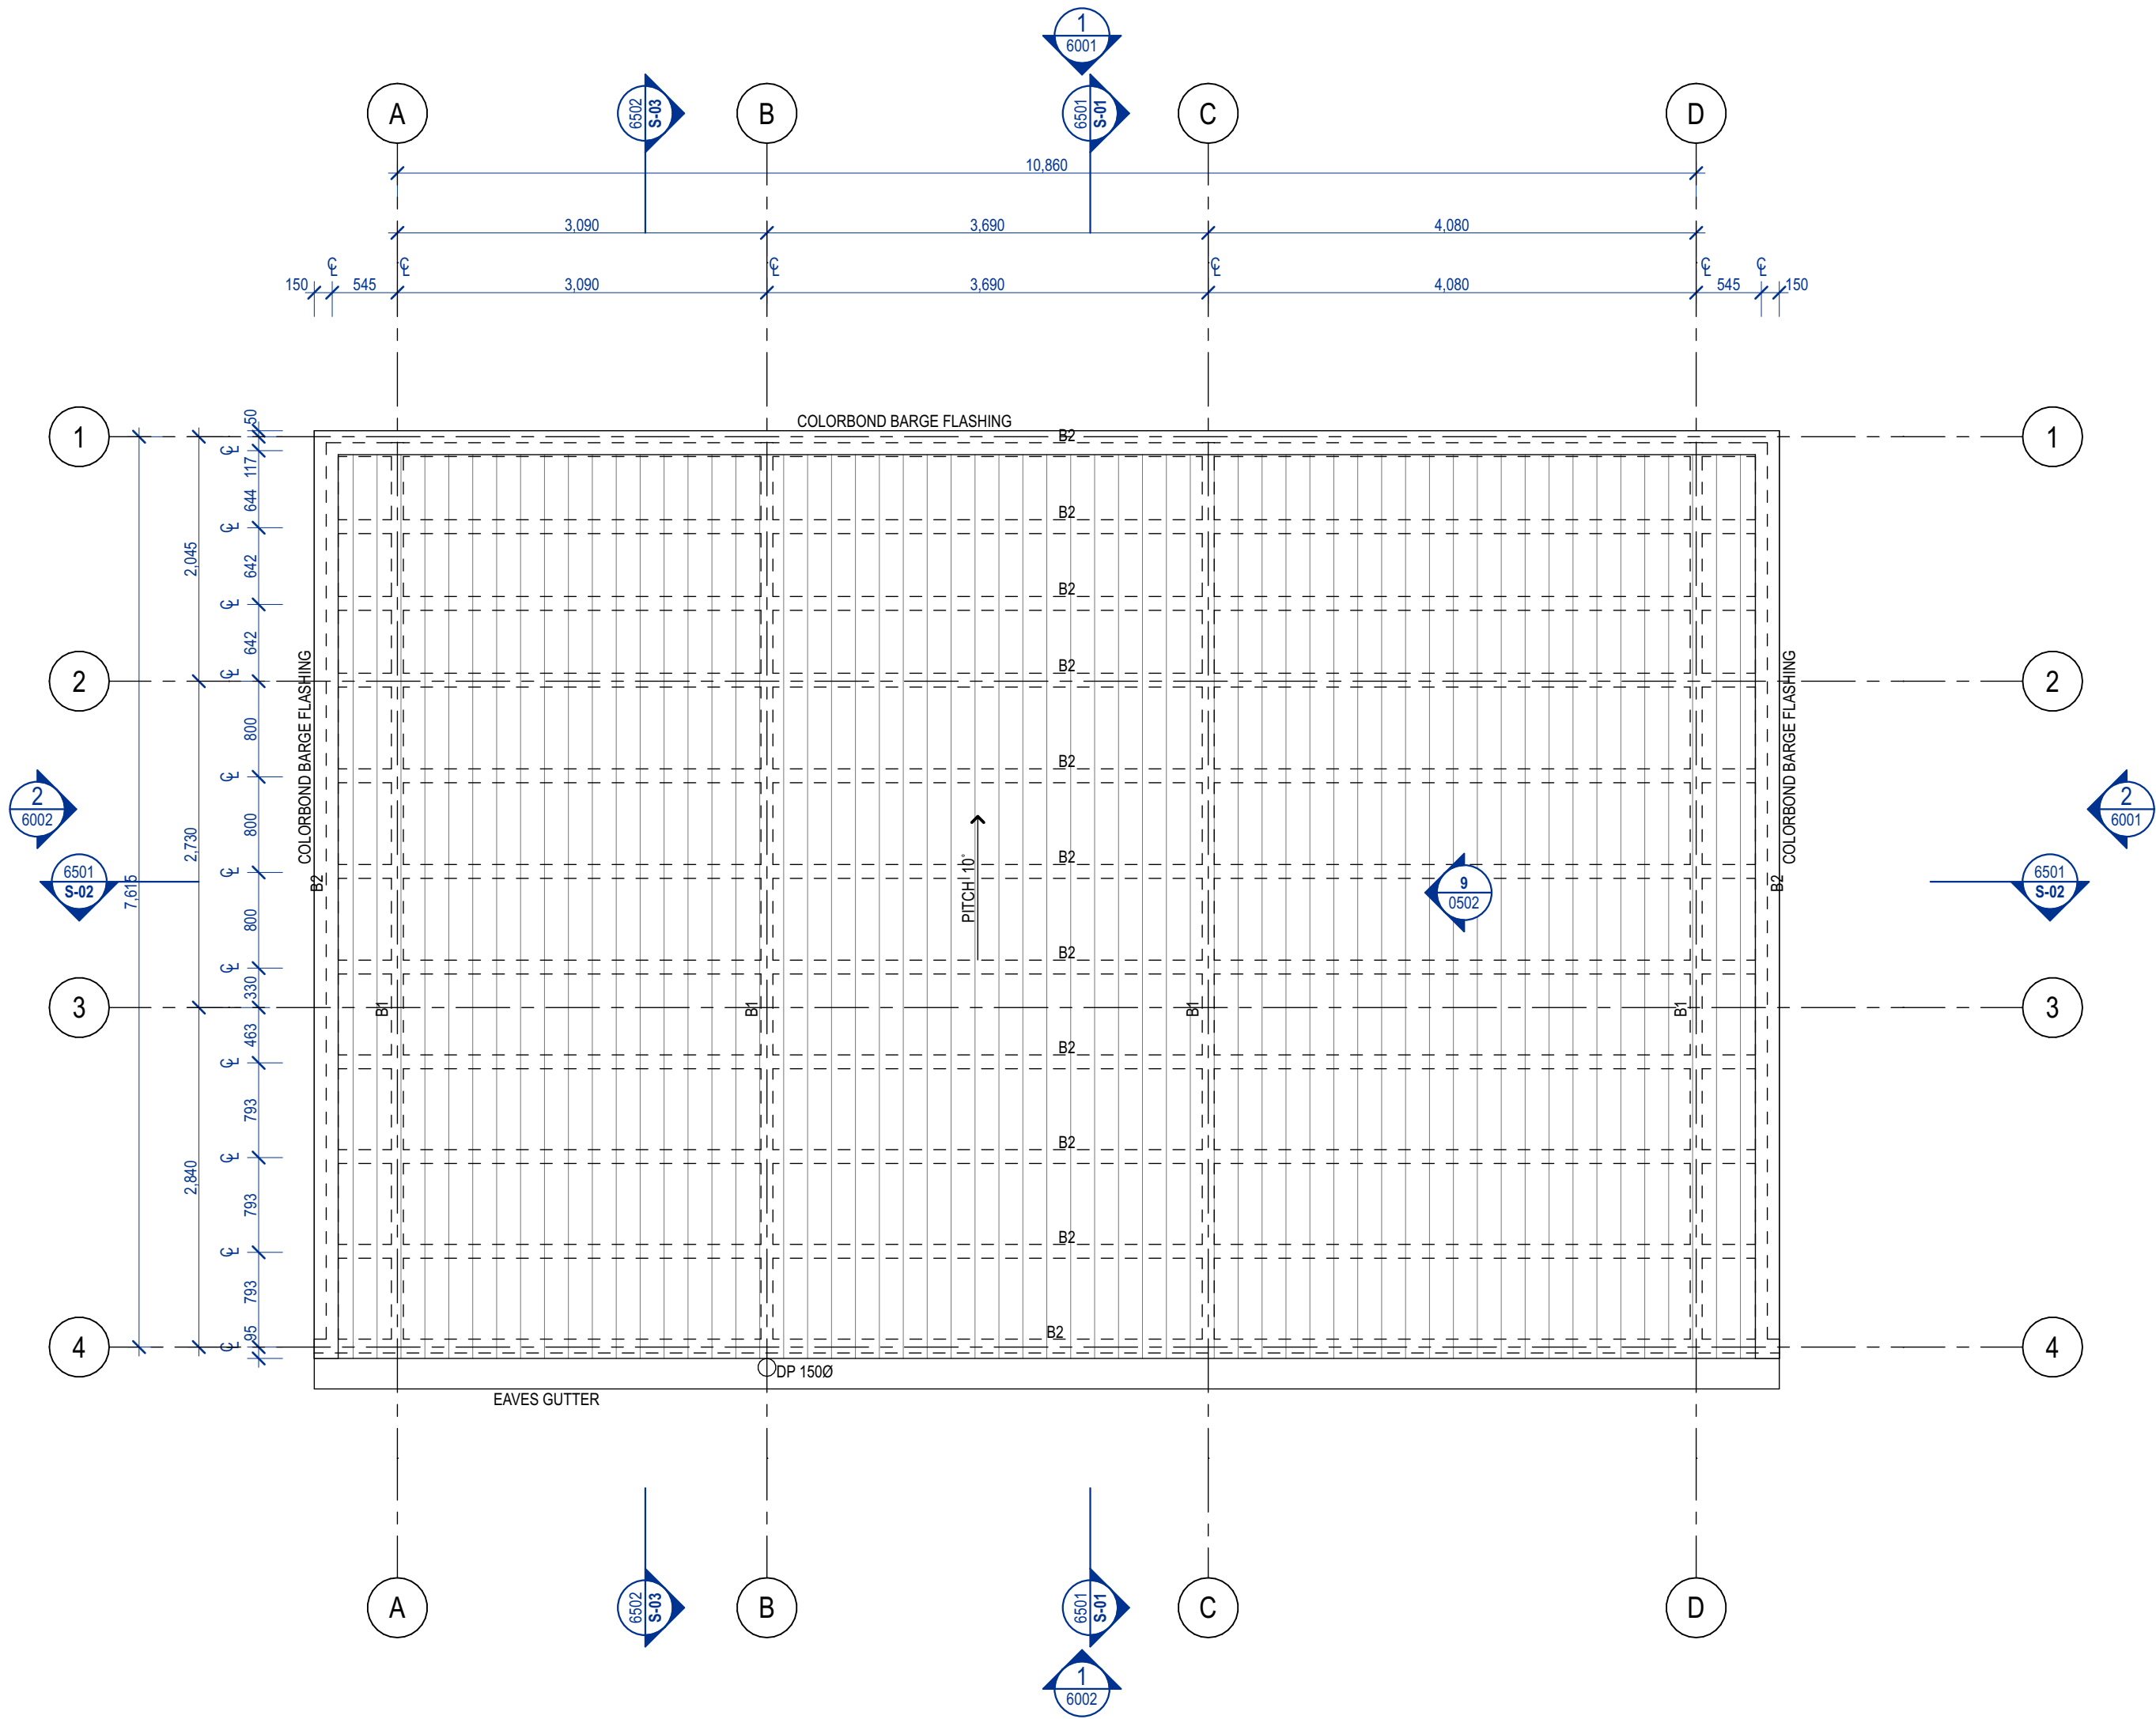

STRUCTURAL MEMBER SIZES:	
100	100 SLAB ON GRADE SL82(T), 30 COVER, N25 CONC 0.2 FORTECON 20MM MAX BEDDED SAND 100MM MIN COMPACTED FCR
BP1	450Ø MASS CONCRETE BORED PIER TO ROCK. 150X10 CAST IN PLATE HDG (TYP)
SF1	450w x 400d STRIP FOOTING 4-11TM(T&B), 50 COVER
B1	200x100x4 RHS, SITE WELD TO C1. DULUX METALSHIELD ZINC GALV SPRAY SITE WELDS
B2	100x4 SHS, SITE WELD TO B1. DULUX METALSHIELD ZINC GALV SPRAY SITE WELDS
C1	100x4 SHS, SITE WELD TO CAST IN PLATE. DULUX METALSHIELD ZINC GALV SPRAY SITE WELDS
C1 OVER	100x4 SHS, 150x10 WITH CAST IN PLATE LOCALLY CORE FILL BLOCKWORK UNDER




Issue ID	Issue Name	Issue Date
A	PRELIMINARY ISSUE	24/2/2026
B	BUILDING APPROVAL ISSUE	10/4/2026
01	CONSTRUCTION ISSUE	20/4/2026

Drawings to be read in conjunction with specification by TA and all drawings and documents by engineers and subconsultants referred to in these plans. Contractors are to verify all dimensions on site before commencing any work or producing shop drawings. Larger scale drawings and written dimensions take preference. Do not scale from drawings. These drawings are protected by the laws of copyright and may not be copied or reproduced without the written permission of TA. all discrepancies to be brought to the attention of the author. All building levels to AHD unless otherwise noted.

FOR CONSTRUCTION-
REV A


ST HELENS MEMORIAL PARK
TOILET AMENITIES
Client: ST HELENS BREAK 'O'DAY COUNCIL
Project Address: 39 CECILIA ST,
ST HELENS,
TAS 7216

CONCRETE -
CONCRETE PROFILE - GROUND
Scale: 1:1, 1:50 @ A2
Status: FOR CONSTRUCTION
Checked By: STA
Date: 7/7/2026

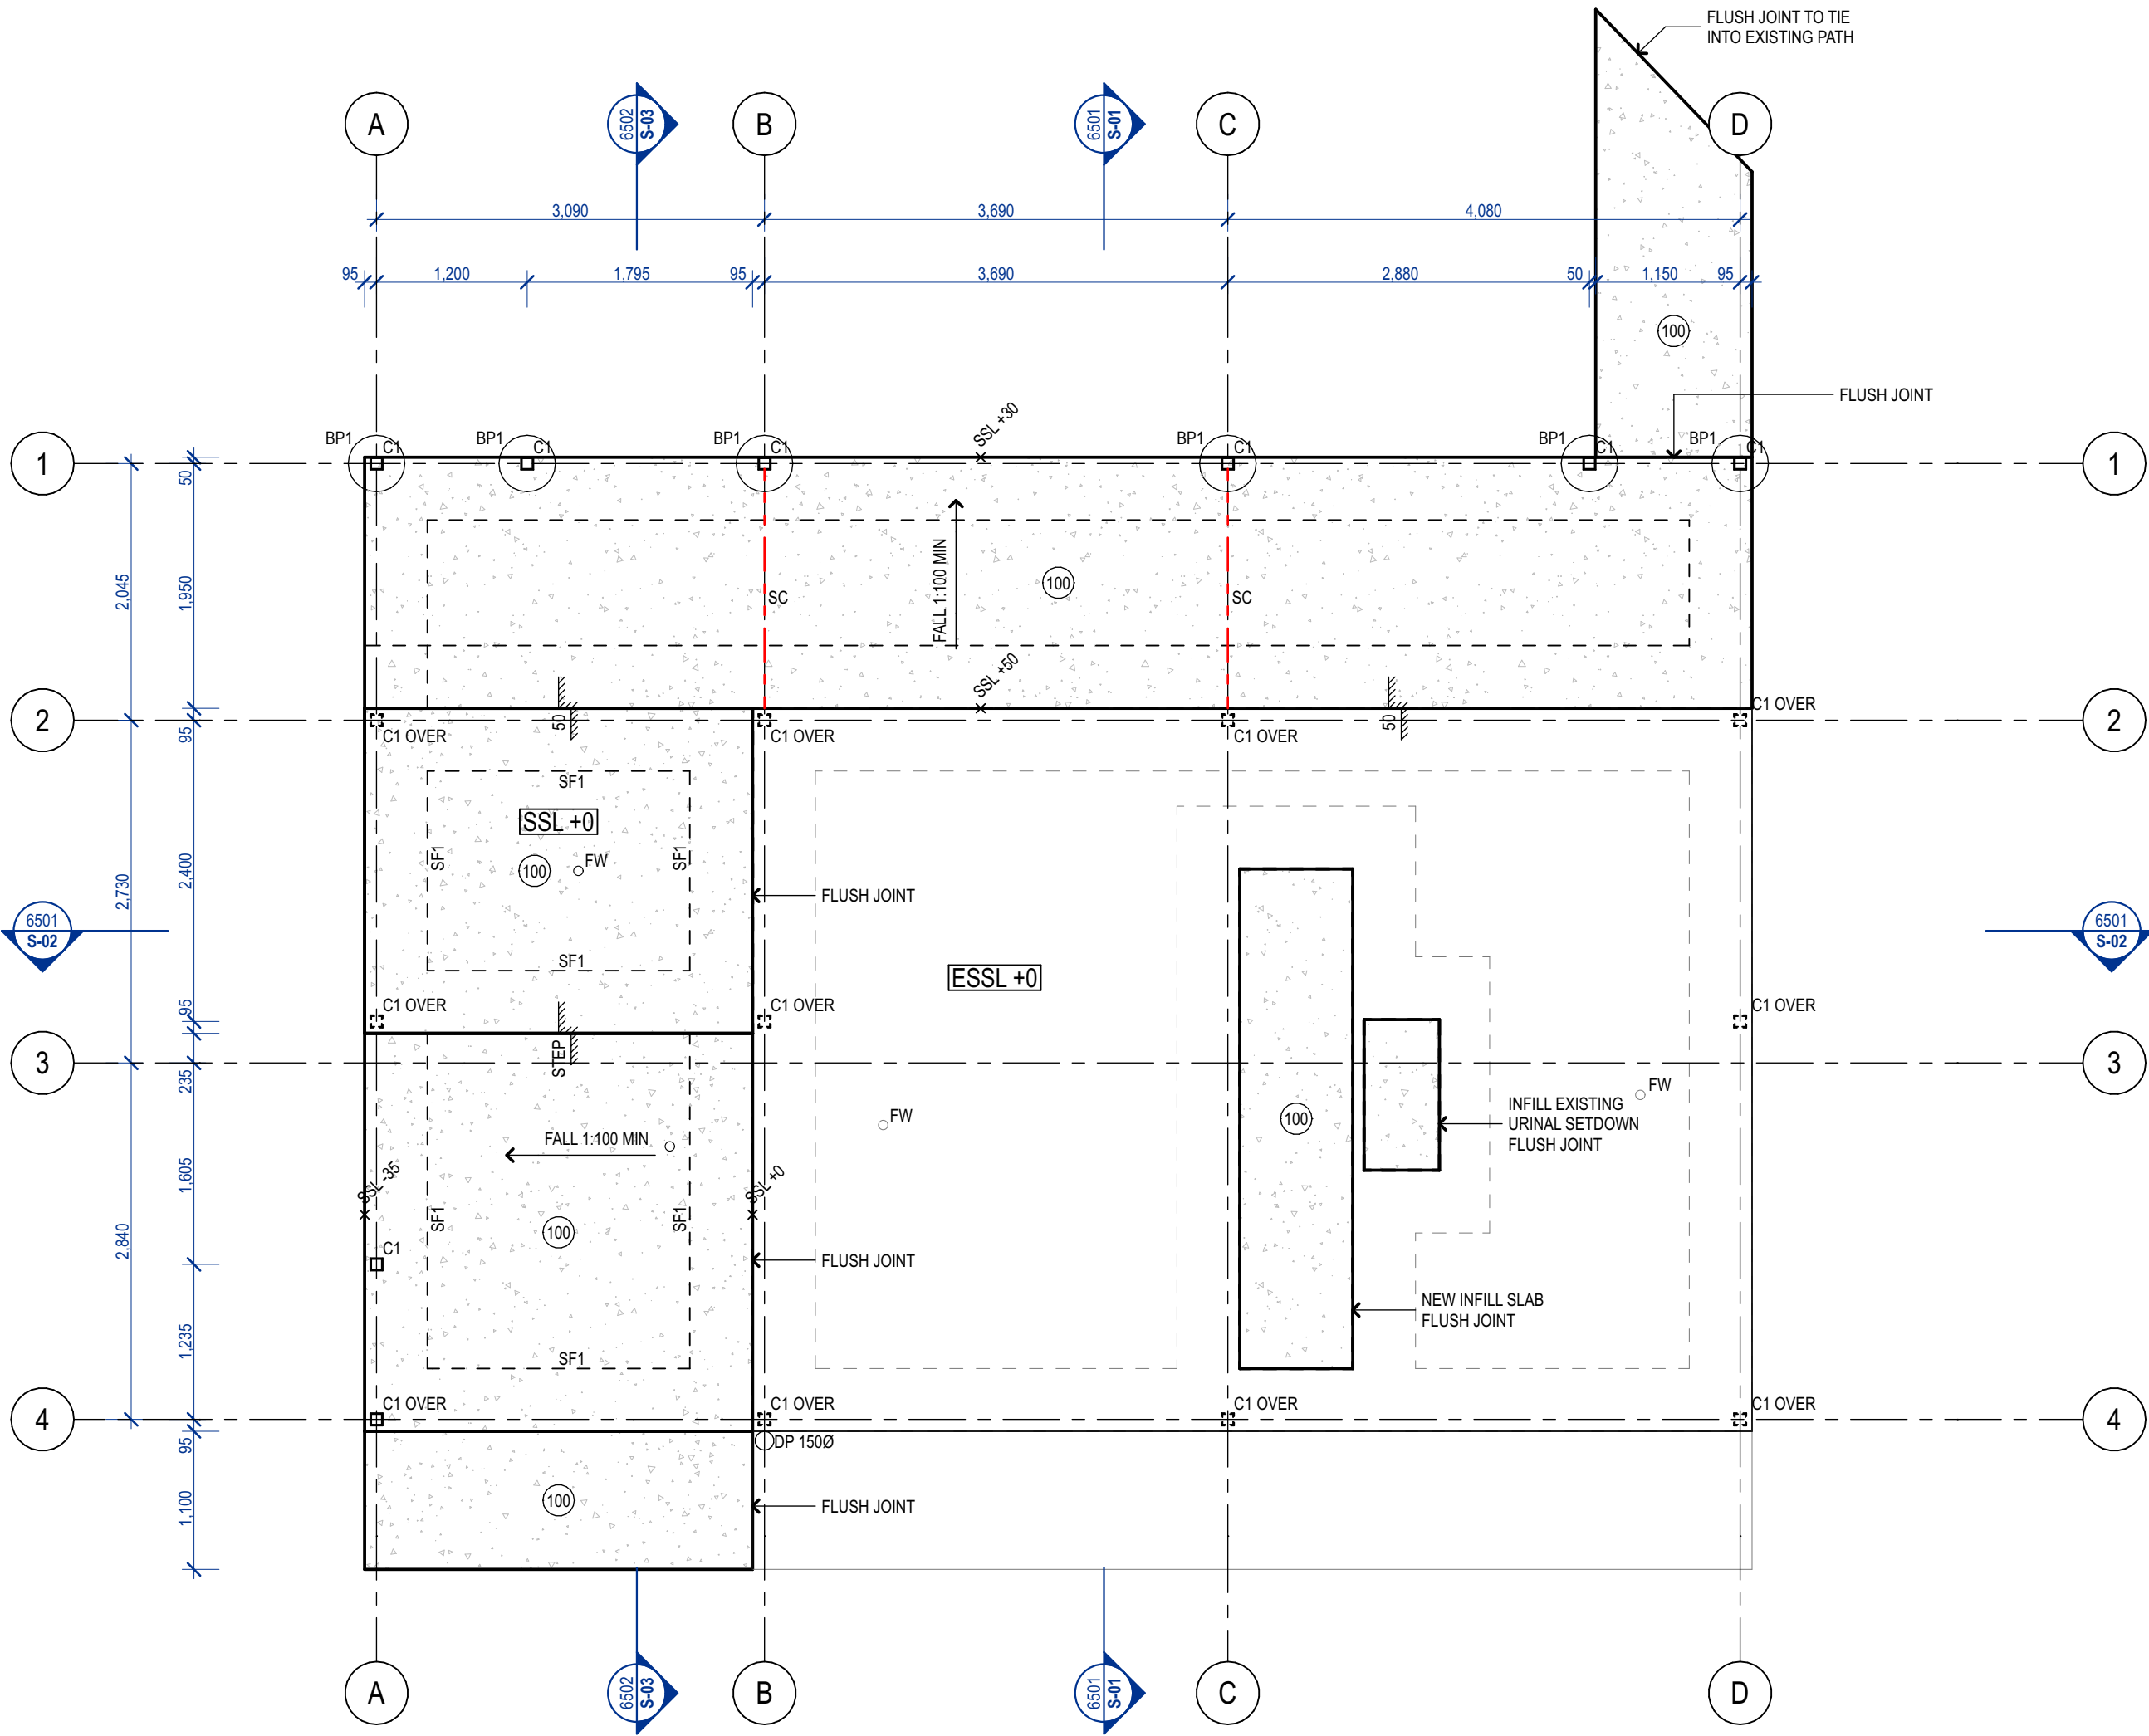


CONCRETE PROFILE PLAN NOTES:
ALL STRUCTURAL DIMENSIONS TO BE CERTIFIED BY STRUCTURAL ENGINEER.
REFER TO SERVICES CONSULTANTS DRAWINGS FOR DETAILS OF SERVICE RUNS AND FOR DETAILS OF CONCRETE PENETRATIONS.

CO-ORDINATE WITH SERVICES TRADE CONTRACTORS FINAL SIZE AND LOCATION OF PLINTHS & PENETRATIONS THROUGH CONCRETE SLABS/WALLS, BLOCKWORK WALLS, AND CONDUITS AND BLOCKOUTS TO BE CAST INTO SLABS AND WALLS.

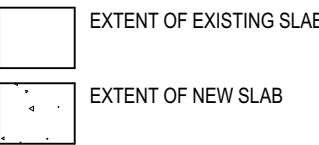


ABBREVIATION LEGEND:	
CJ	CONSTRUCTION JOINT
COL	COLUMN
COS	CHECK ON SITE
DP	DOWN PIPE
ESSL	EXISTING STRUCTURAL LEVEL
FFL	FINISH FLOOR LEVEL
FW	FLOOR WASTE
MJ	MOVEMENT JOINT
PMJ	PERMANENT MOVEMENT JOINT
RL	REQUIRED LEVEL
SSL	STRUCTURAL SLAB LEVEL (NEW)
TMJ	TEMPORARY MOVEMENT JOINT

STRUCTURAL MEMBER SIZES:	
100	100 SLAB ON GRADE SL82(T), 30 COVER, N25 CONC 0.2 FORTECON 20MM MAX BEDDED SAND 100MM MIN COMPACTED FCR
BP1	450Ø MASS CONCRETE BORED PIER TO ROCK. 150X10 CAST IN PLATE HDG (TYP)
SF1	450w x 400d STRIP FOOTING 4-11TM(T&B), 50 COVER
B1	200x100x4 RHS, SITE WELD TO C1. DULUX METALSHIELD ZINC GALV SPRAY SITE WELDS
B2	100x4 SHS, SITE WELD TO B1. DULUX METALSHIELD ZINC GALV SPRAY SITE WELDS
C1	100x4 SHS, SITE WELD TO CAST IN PLATE. DULUX METALSHIELD ZINC GALV SPRAY SITE WELDS
C1 OVER	100x4 SHS, 150x10 WITH CAST IN PLATE LOCALLY CORE FILL BLOCKWORK UNDER
SC	30mm DEEP SAW CUT AT 25 HOURS MAX.

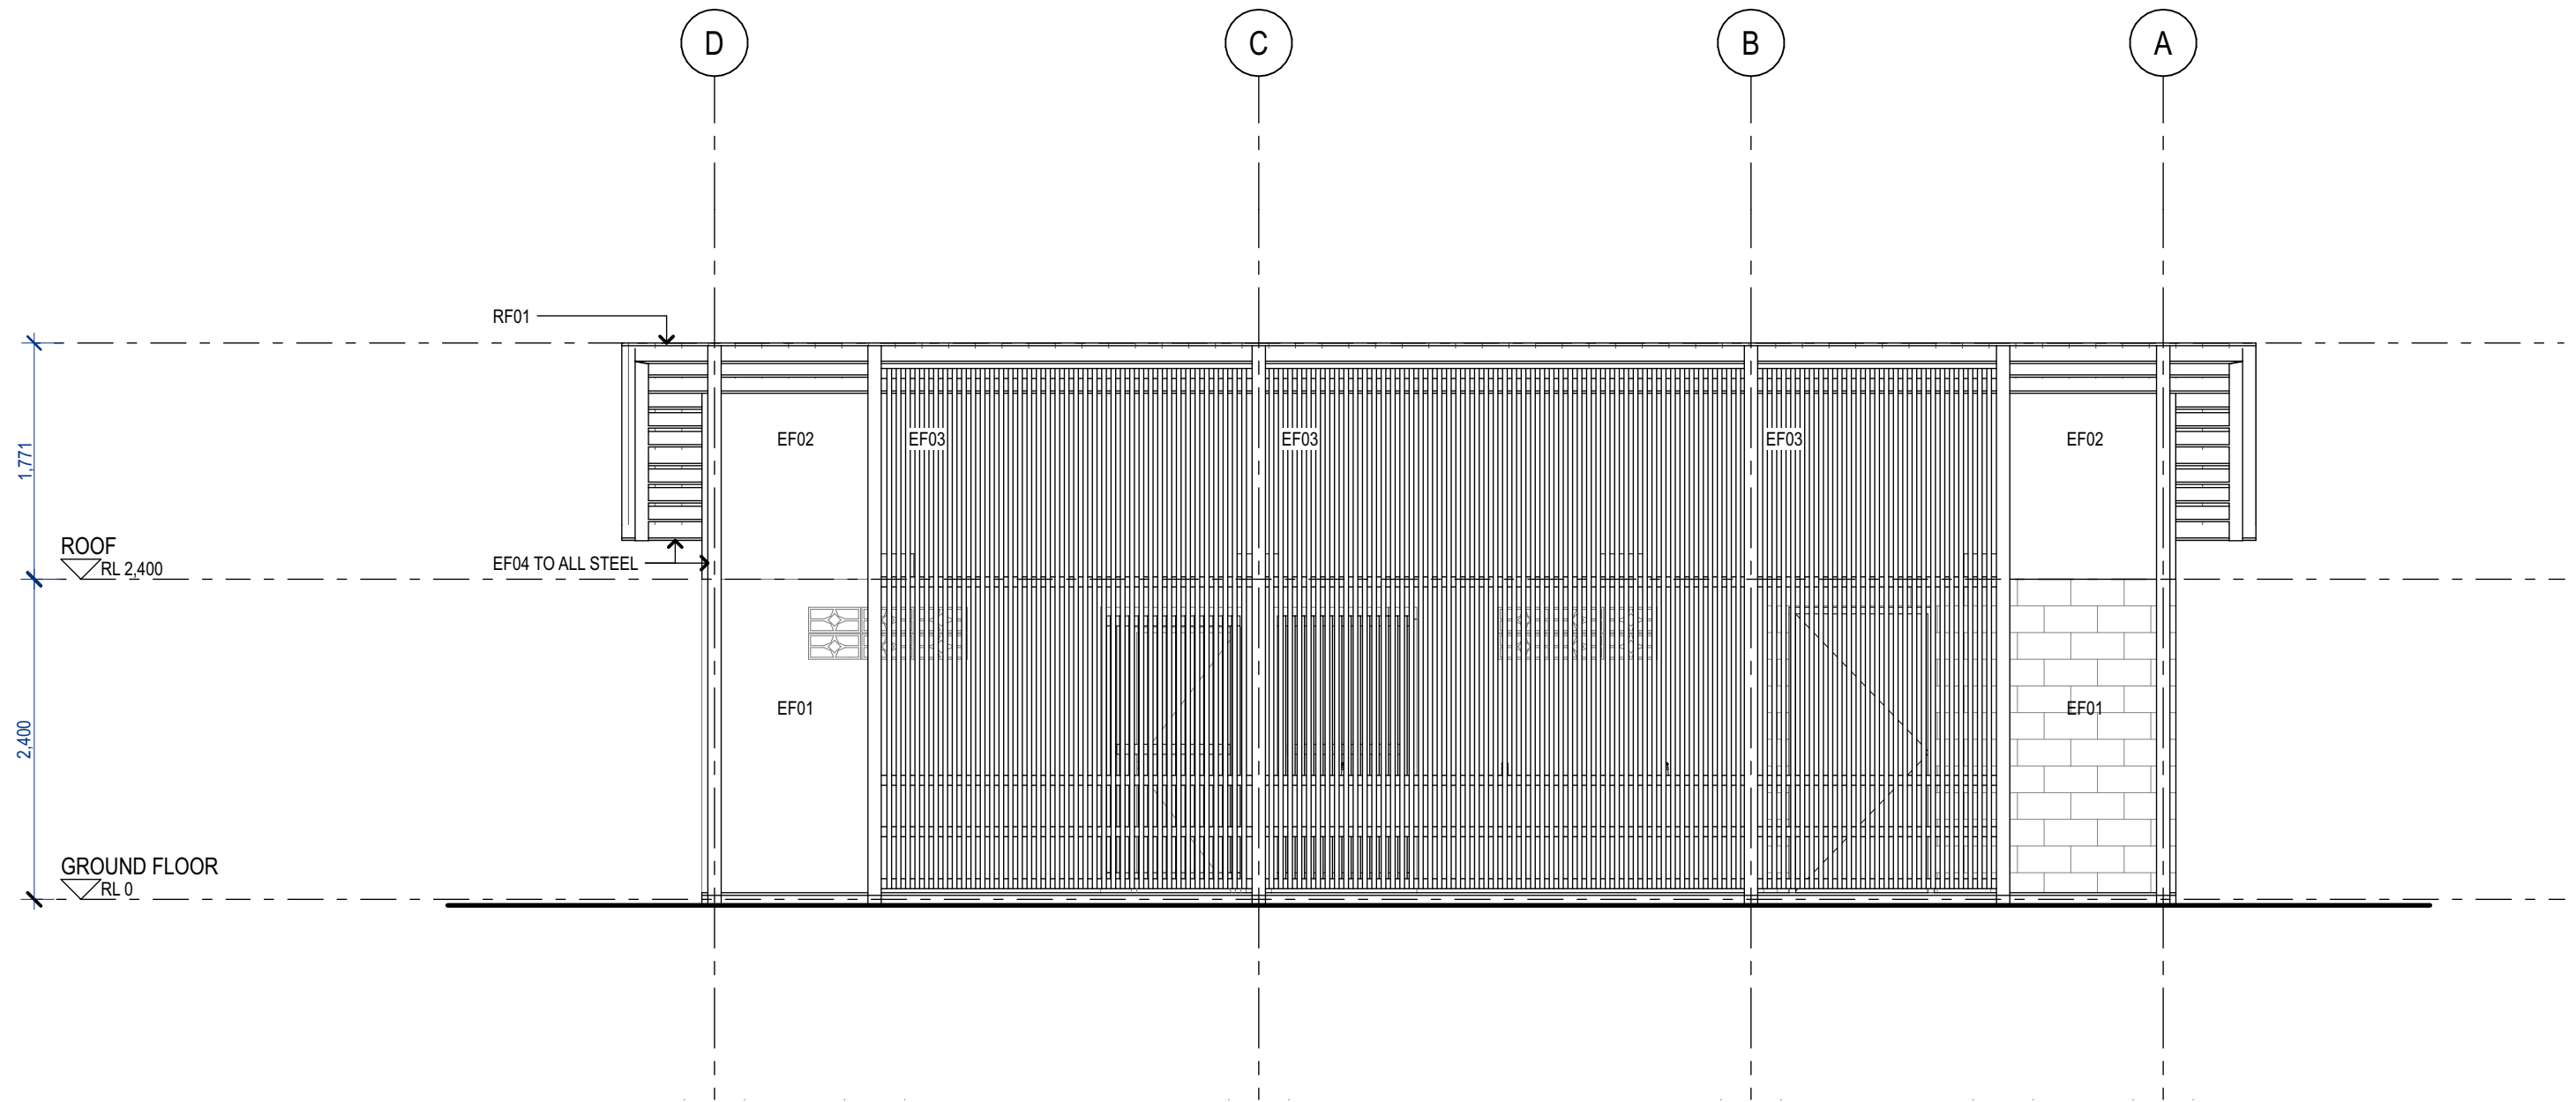

1 NORTH ELEVATION
- 1:50

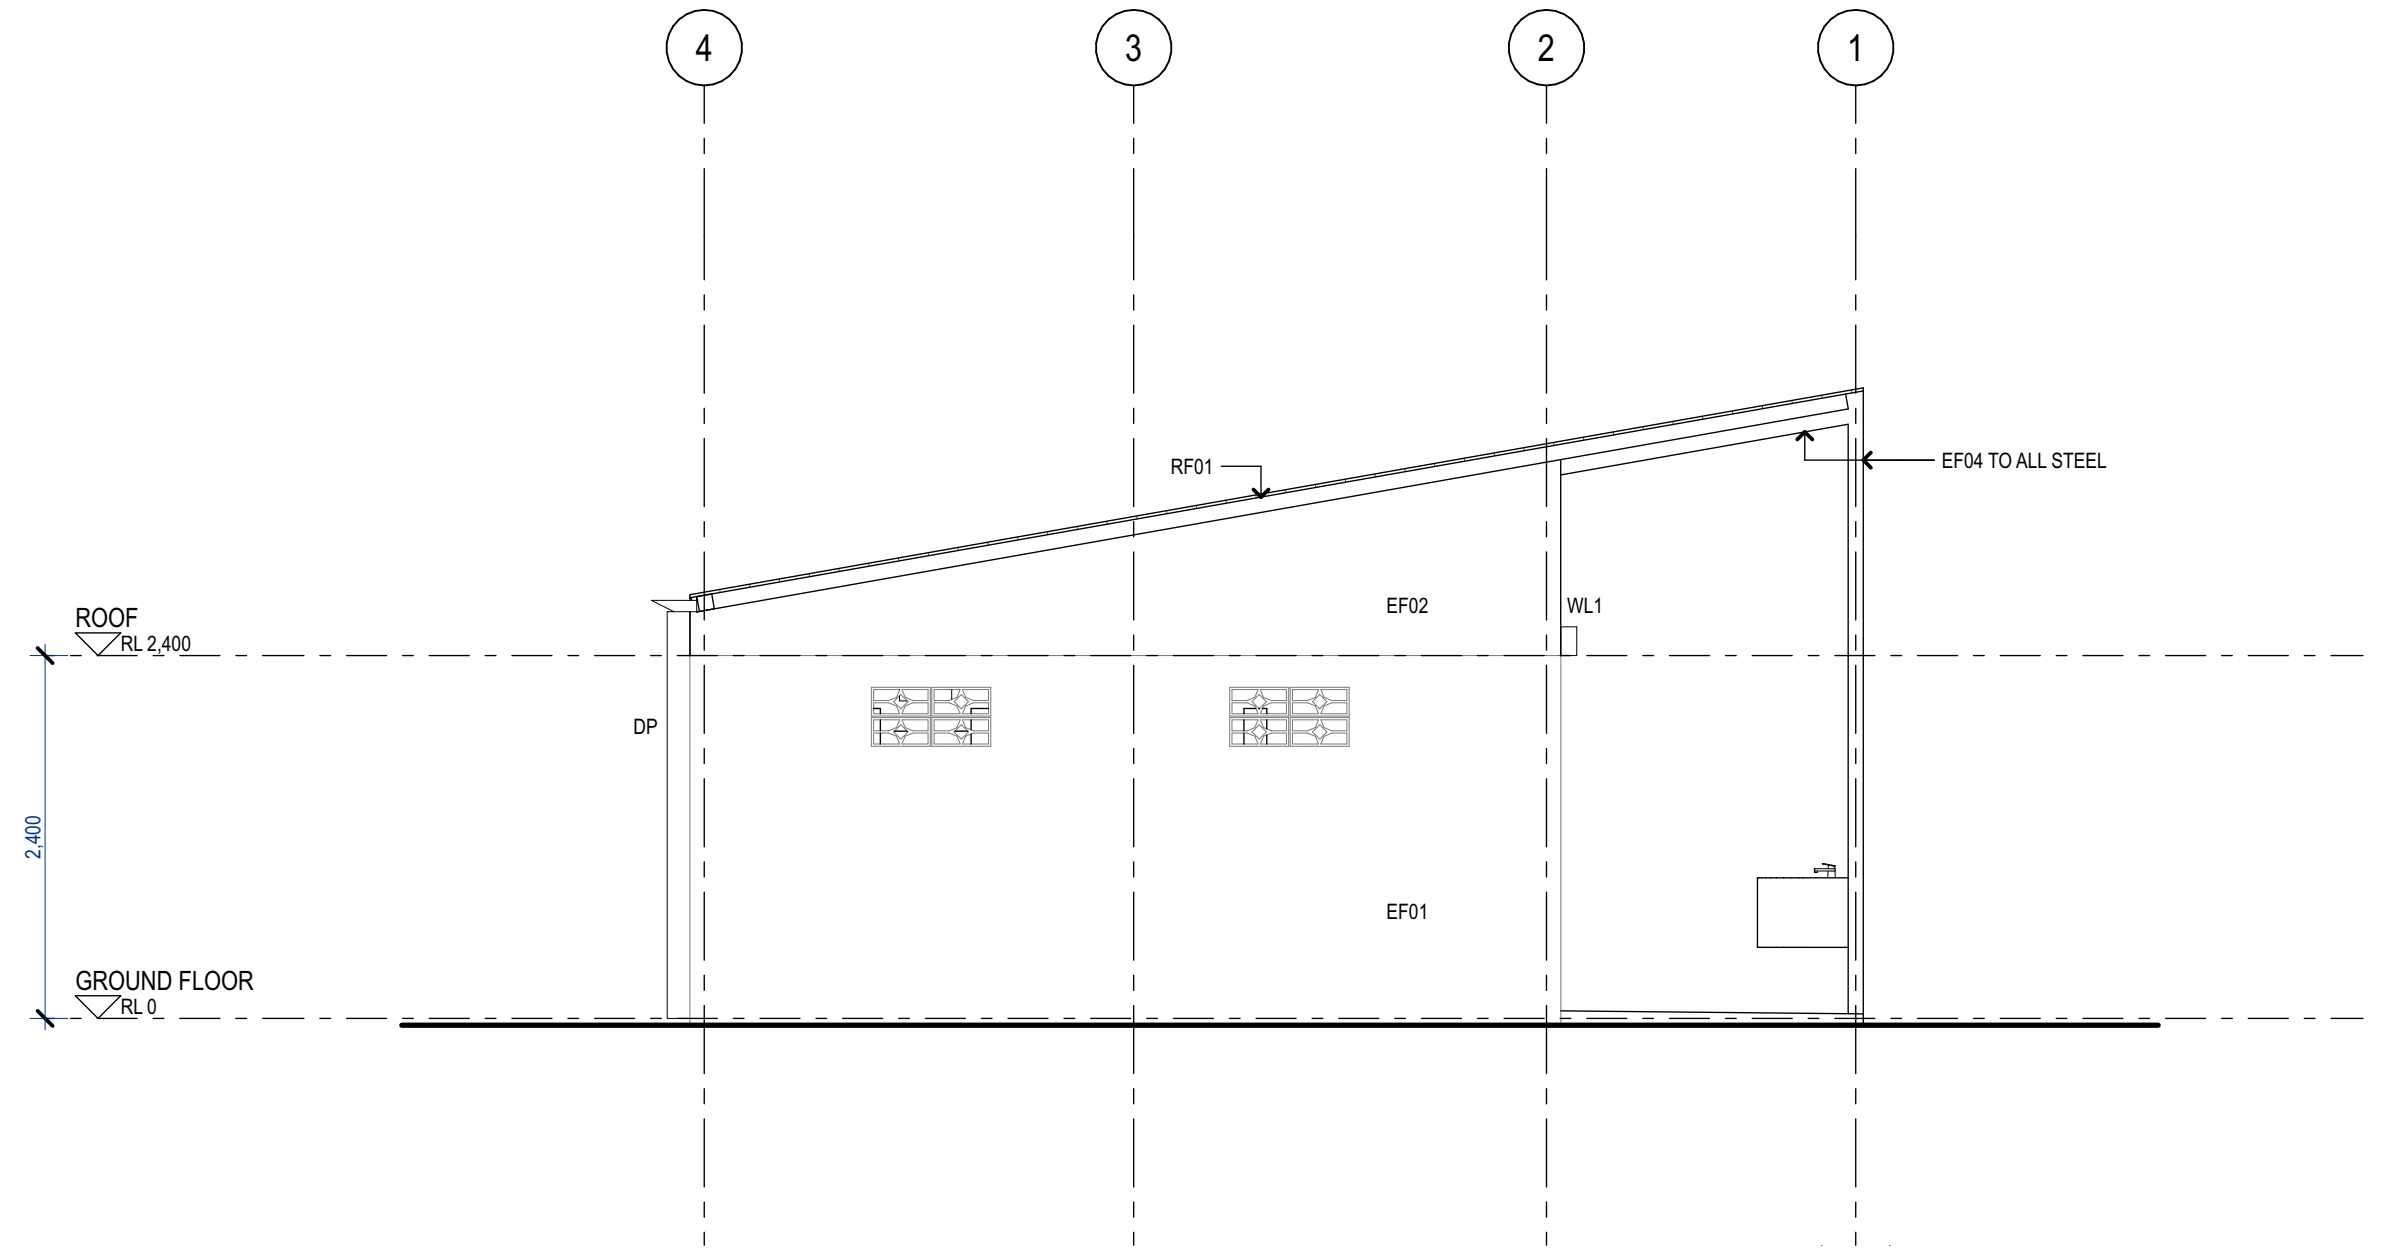

2 EAST ELEVATION
- 1:50

Issue ID	Issue Name	Issue Date
A	PRELIMINARY ISSUE	24/2/2026
B	BUILDING APPROVAL ISSUE	10/4/2026
01	CONSTRUCTION ISSUE	20/4/2026

Drawings to be read in conjunction with specification by TA and all drawings and documents by engineers and subconsultants referred to in these plans. Contractors are to verify all dimensions on site before commencing any work or producing shop drawings. Larger scale drawings and written dimensions take preference. Do not scale from drawings. These drawings are protected by the laws of copyright and may not be copied or reproduced without the written permission of TA. All discrepancies to be brought to the attention of the author. All building levels to AHD unless otherwise noted.


FOR CONSTRUCTION -
REV A

ST HELENS MEMORIAL PARK
TOILET AMENITIES


Client
ST HELENS BREAK 'O'DAY COUNCIL
Project Address
39 CECILIA ST,
ST HELENS,
TAS 7216

ELEVATIONS -
ELEVATIONS - NORTH & EAST

Scale: 1:50 @ A2
Status: FOR CONSTRUCTION
Checked By: STA
Date: 7/7/2026

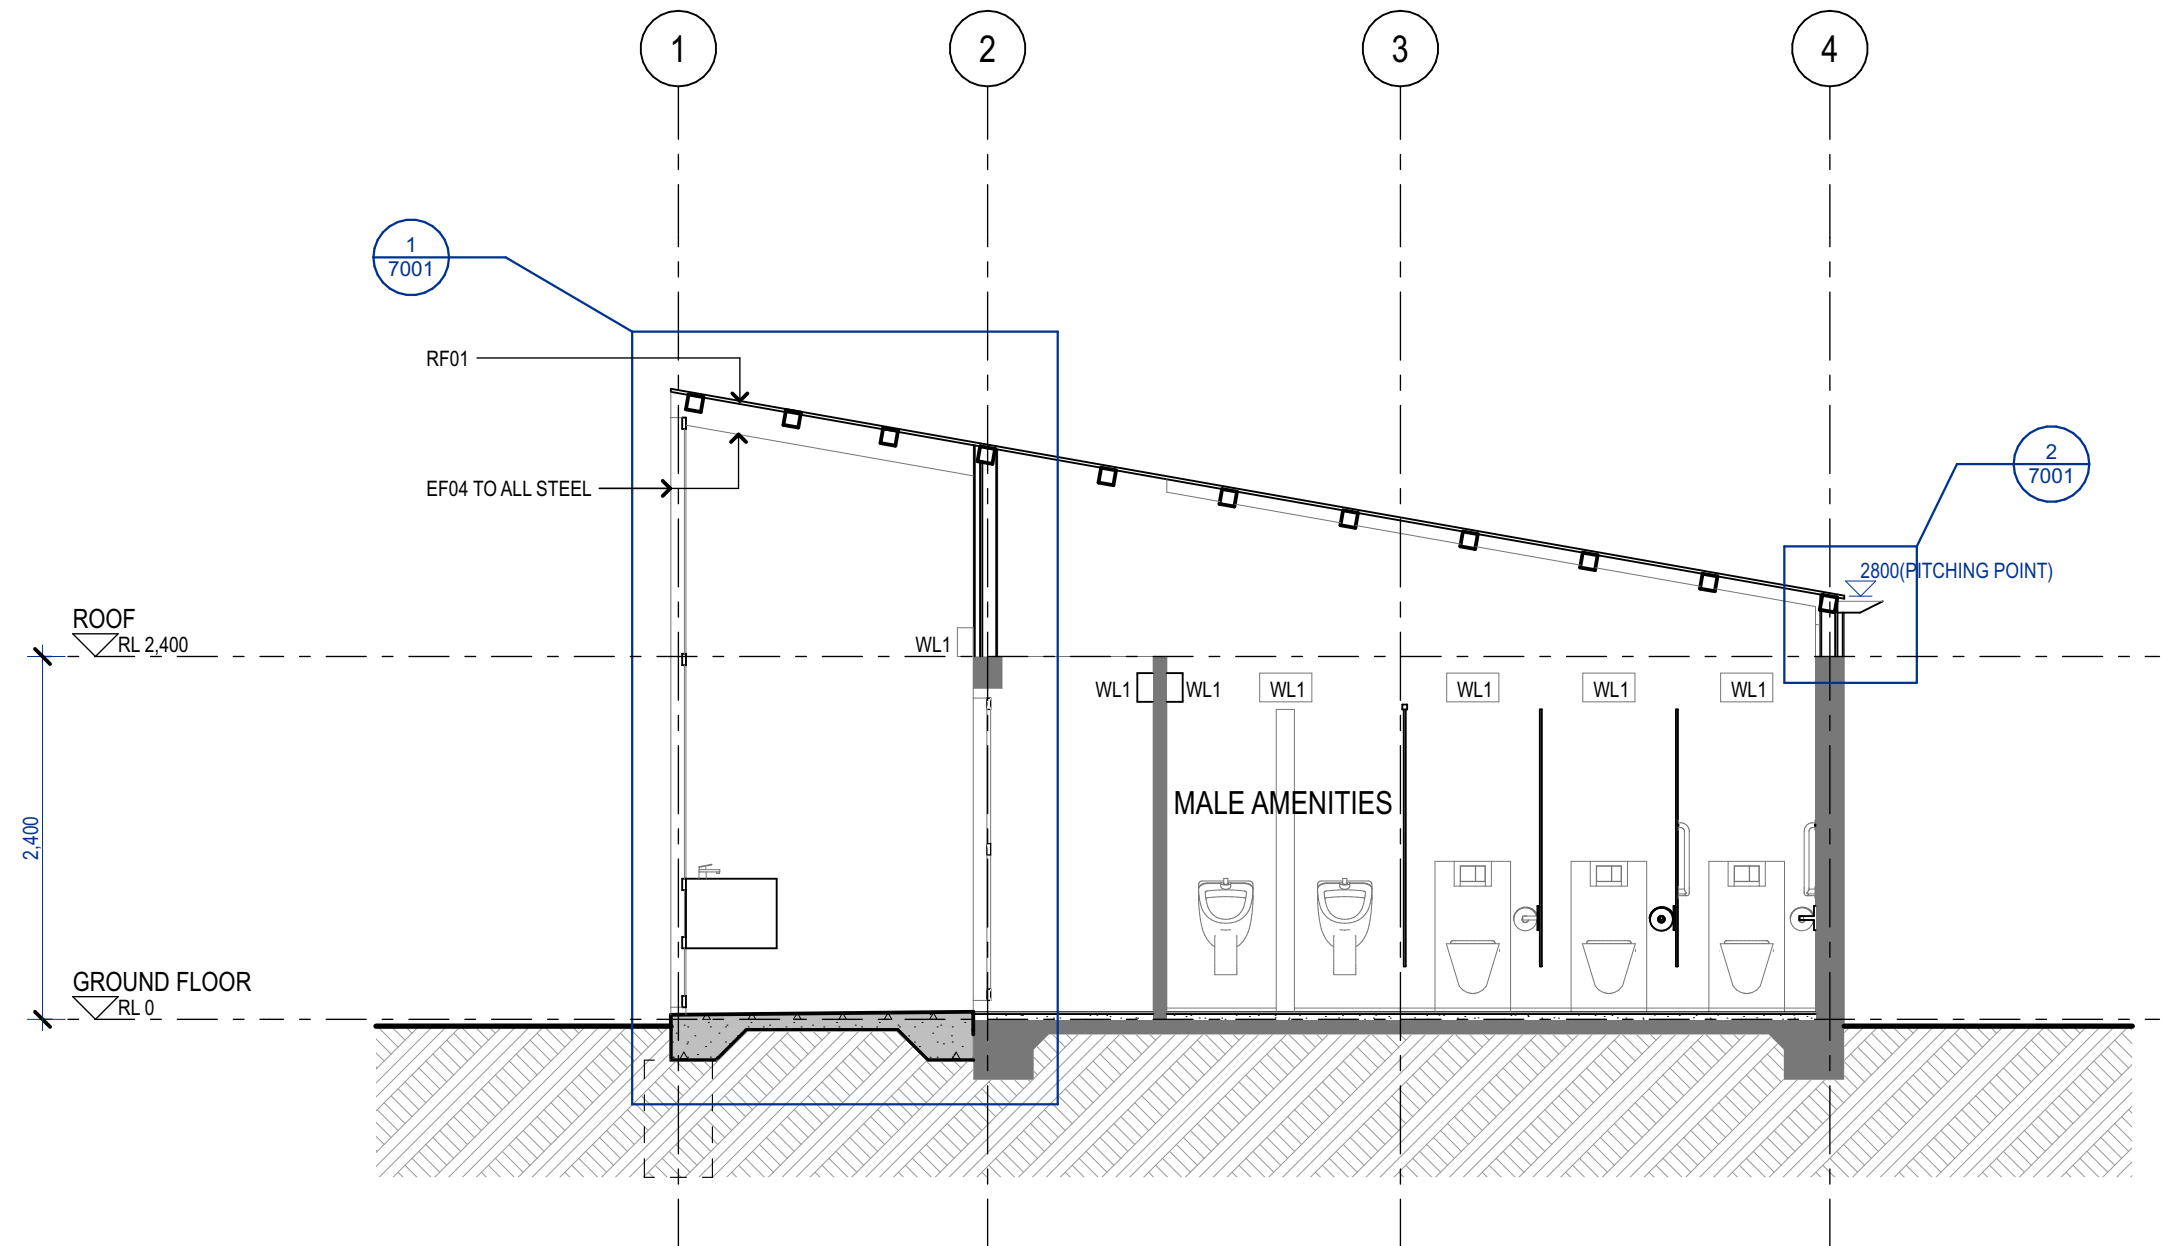

1 SECTION A
- 1:50

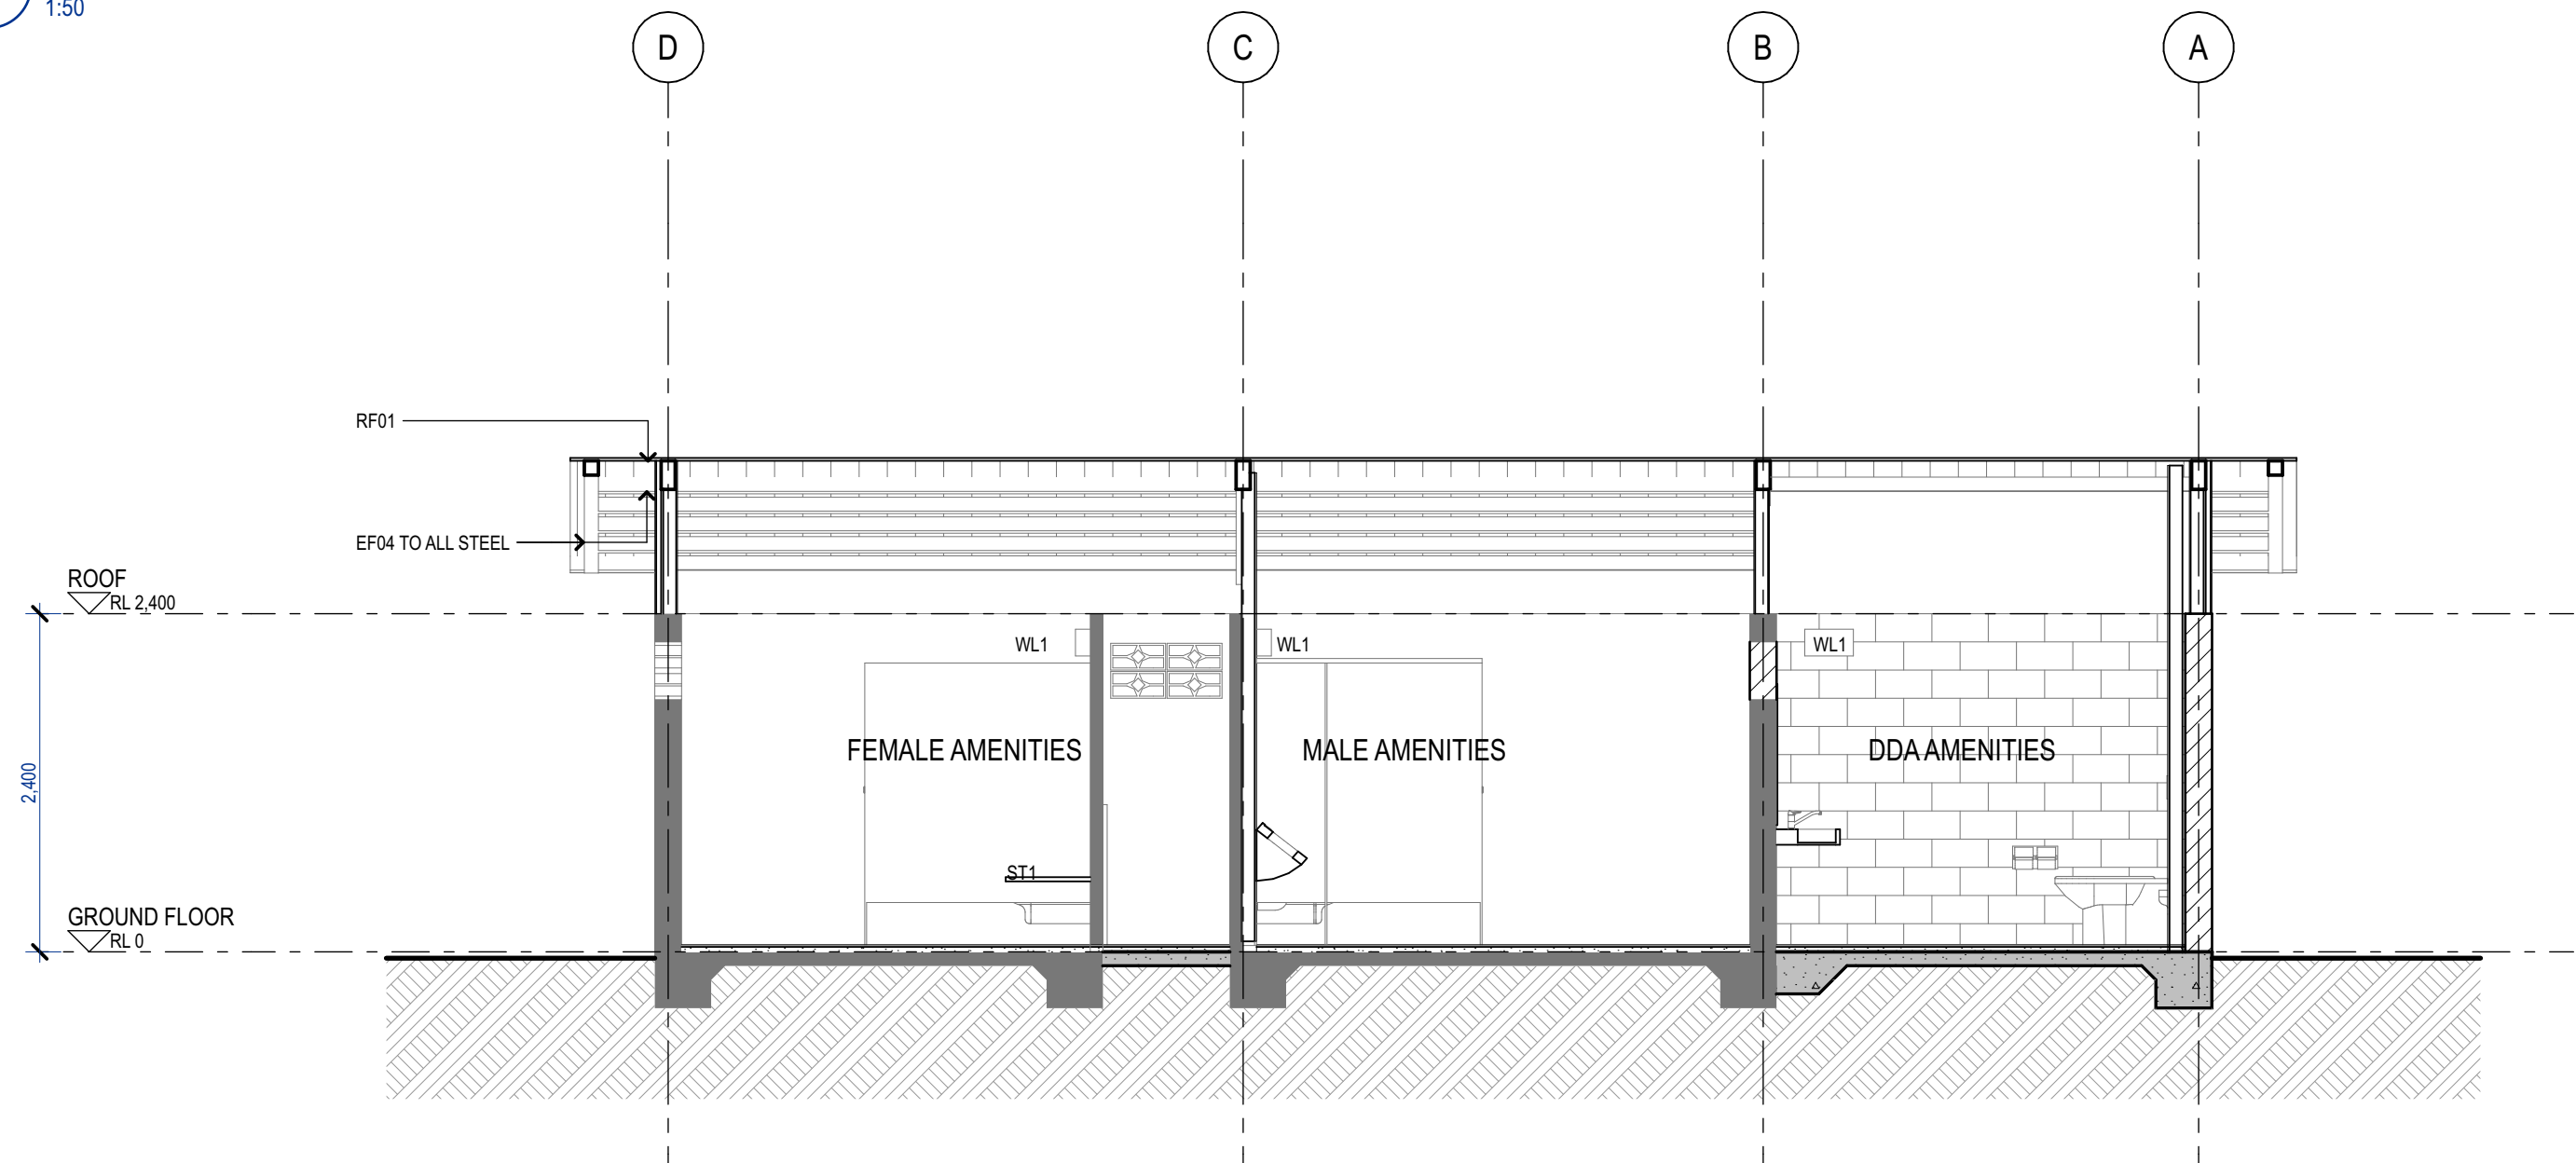

2 SECTION B
- 1:50

TANNER ARCHITECTS™

03 6224 4377

mail@tanner-architects.com.au

Accreditation: 329877575

Issue ID	Issue Name	Issue Date
A	PRELIMINARY ISSUE	24/2/2026
B	BUILDING APPROVAL ISSUE	10/4/2026
01	CONSTRUCTION ISSUE	20/4/2026

Drawings to be read in conjunction with specification by TA and all drawings and documents by engineers and subconsultants referred to in these plans. Contractors are to verify all dimensions on site before commencing any work or producing shop drawings. Larger scale drawings and written dimensions take preference. Do not scale from drawings. These drawings are protected by the laws of copyright and may not be copied or reproduced without the written permission of TA. All discrepancies to be brought to the attention of the author. All building levels to AHD unless otherwise noted.

FOR CONSTRUCTION -
REV A

Project Name
ST HELENS MEMORIAL PARK
TOILET AMENITIES
Client
ST HELENS BREAK 'O'DAY COUNCIL
Project Address
39 CECILIA ST,
ST HELENS,
TAS 7216

SECTIONS -
SECTIONS A & B
Scale: 1:50 @ A2
Status: FOR CONSTRUCTION
Checked By: STA
Date: 7/7/2026


6501
01




Drawings to be read in conjunction with specification by TA and all drawings and documents by engineers and subconsultants referred to in these plans. Contractors are to verify all dimensions on site before commencing any work or producing shop drawings. Larger scale drawings and written dimensions take preference. Do not scale from drawings. These drawings are protected by the laws of copyright and may not be copied or reproduced without the written permission of TA. All discrepancies to be brought to the attention of the author. All building levels to AHD unless otherwise noted.

Project Name
**ST HELENS MEMORIAL PARK
TOILET AMENITIES**
Client
ST HELENS BREAK O'DAY COUNCIL
Project Address
**39 CECILIA ST,
ST HELENS,
TAS 7216**

6502
01

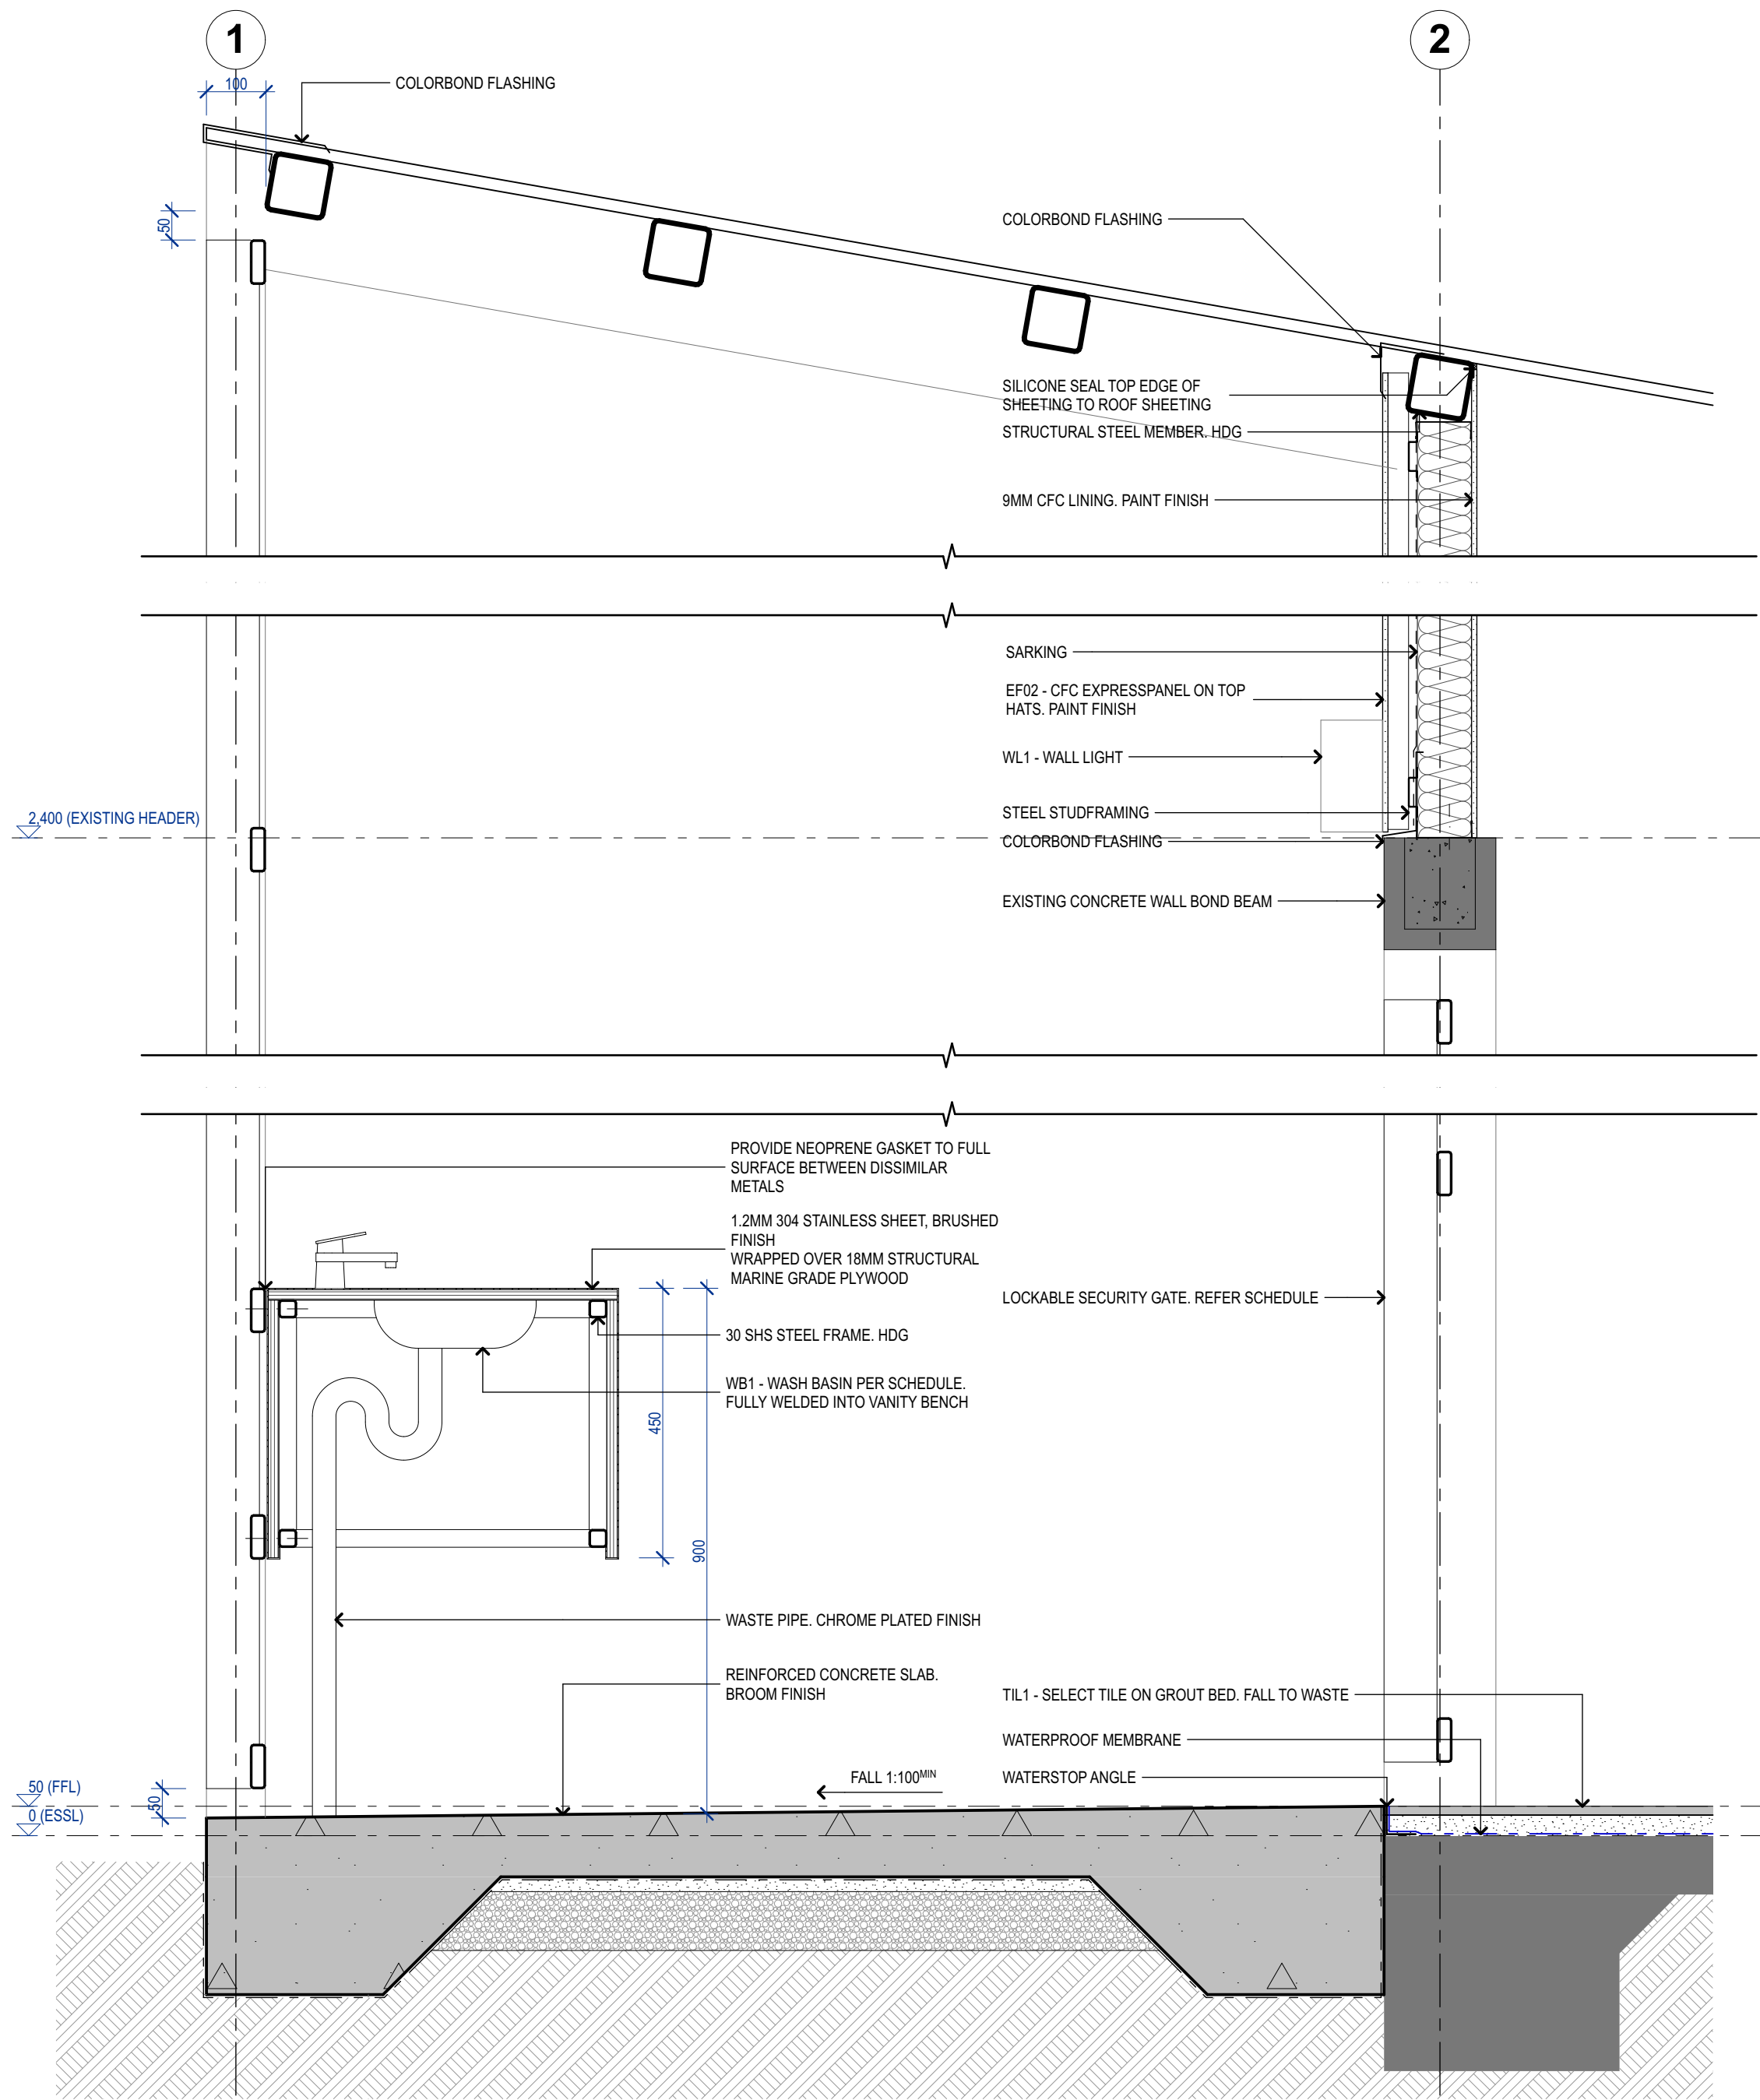

2 SECTION DETAIL
1:10

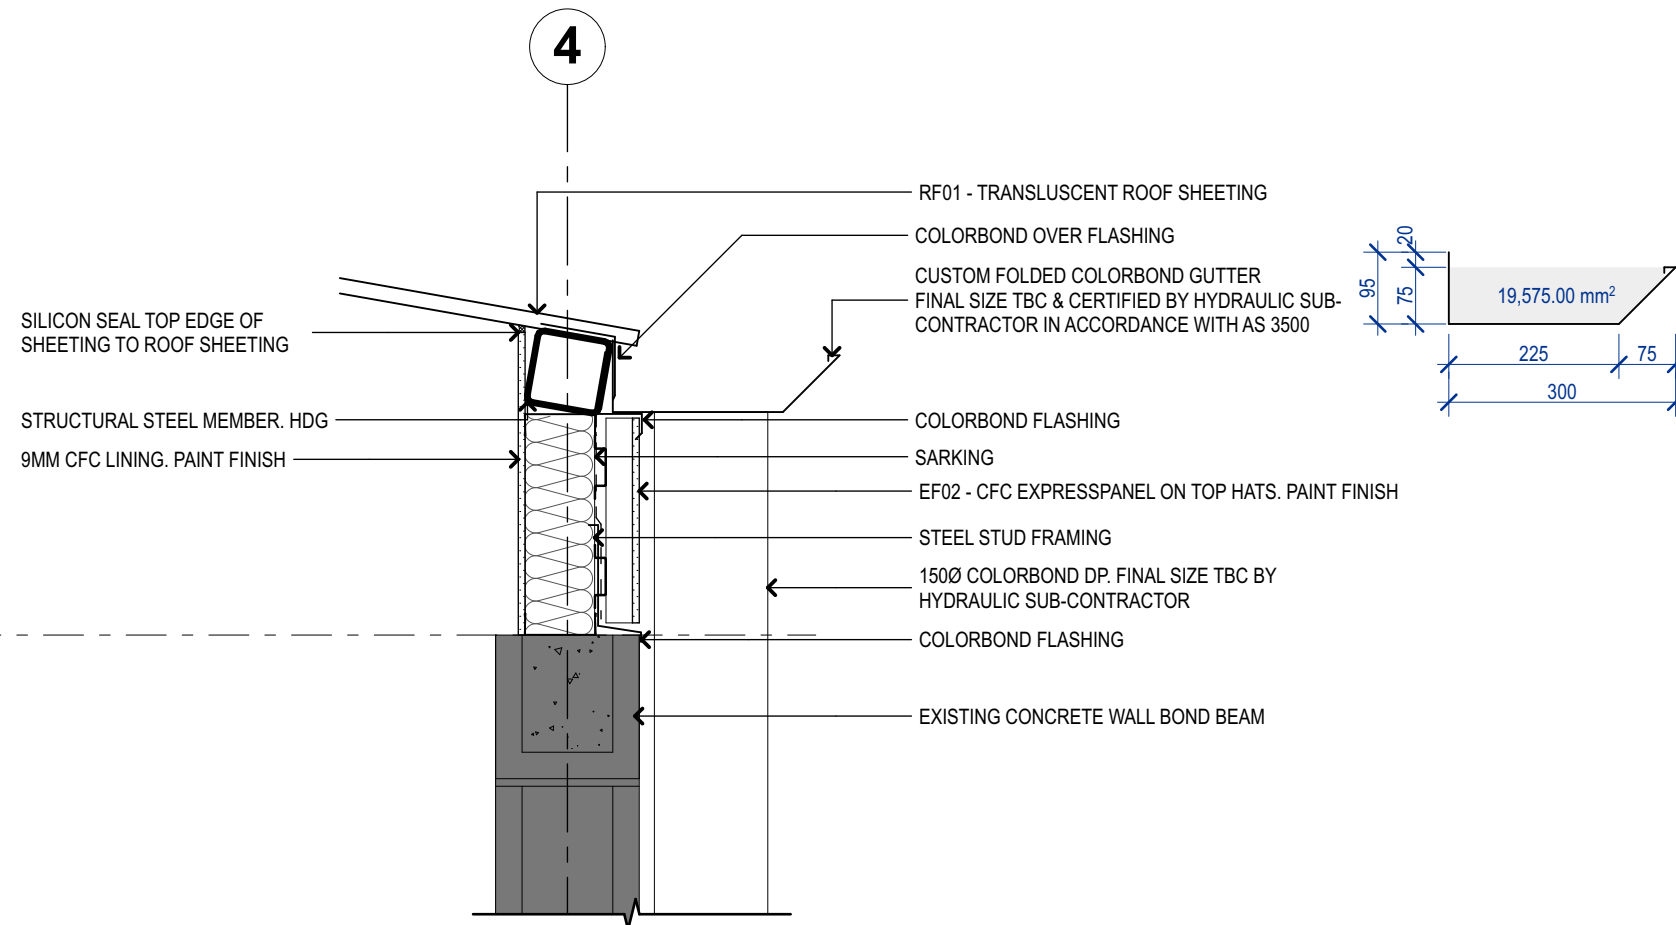

1 SECTION DETAIL
1:10


Issue ID	Issue Name	Issue Date
A	BUILDING APPROVAL ISSUE	10/4/2026
01	CONSTRUCTION ISSUE	20/4/2026

Drawings to be read in conjunction with specification by TA and all drawings and documents by engineers and subconsultants referred to in these plans. Contractors are to verify all dimensions on site before commencing any work or producing shop drawings. Larger scale drawings and written dimensions take preference. Do not scale from drawings. These drawings are protected by the laws of copyright and may not be copied or reproduced without the written permission of TA. All discrepancies to be brought to the attention of the author. All building levels to AHD unless otherwise noted.


FOR CONSTRUCTION -
REV A

Project Name
ST HELENS MEMORIAL PARK
TOILET AMENITIES
Client
ST HELENS BREAK 'O'DAY COUNCIL
Project Address
39 CECILIA ST,
ST HELENS,
TAS 7216


DETAILS -
DETAILS - SHEET 1
Scale: 1:10 @ A2
Status: FOR CONSTRUCTION
Checked By: STA
Date: 7/7/2026

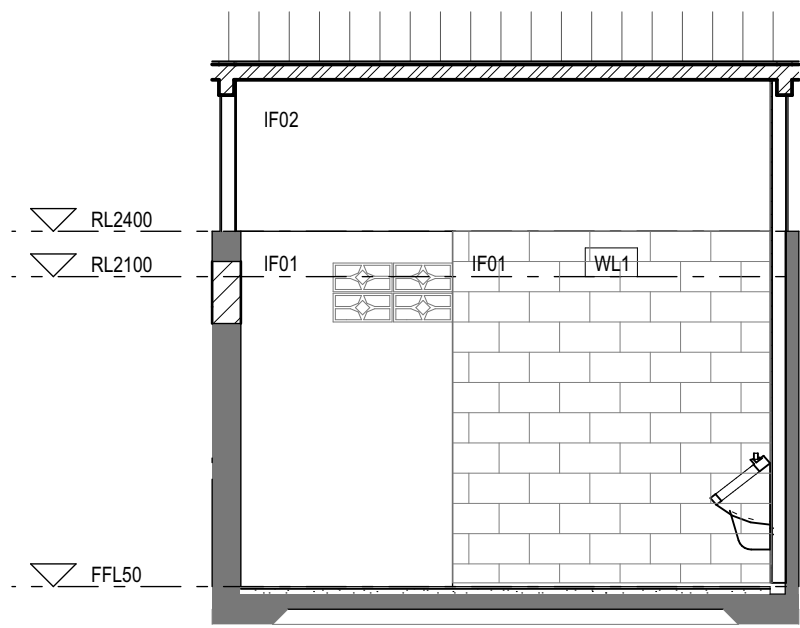


01 MALE AMENITIES
1:50

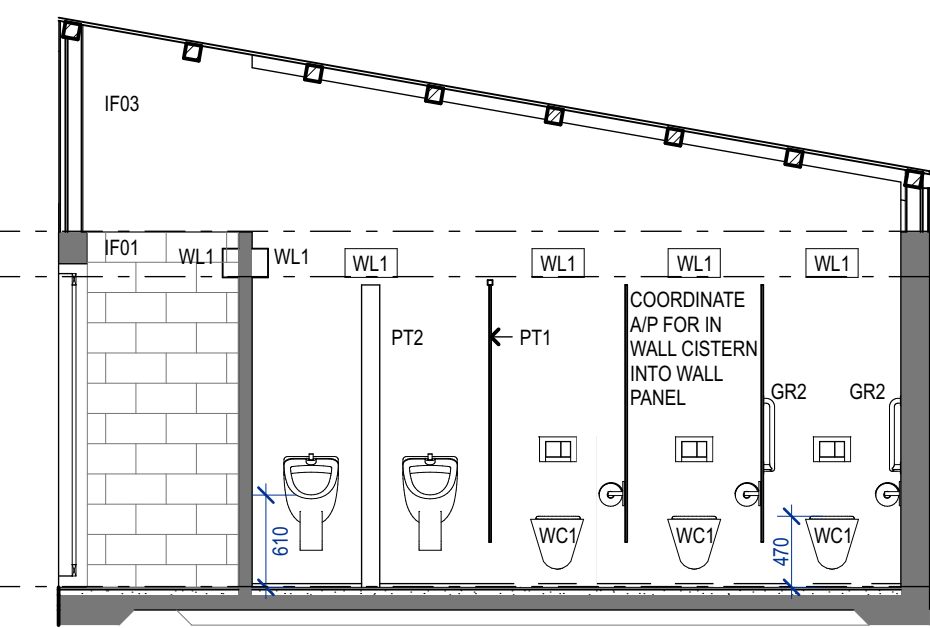


02 MALE AMENITIES
1:50

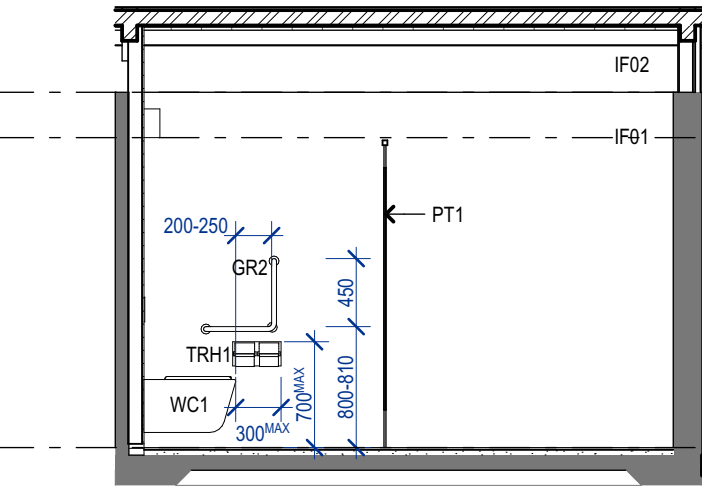


03 MALE AMENITIES
1:50

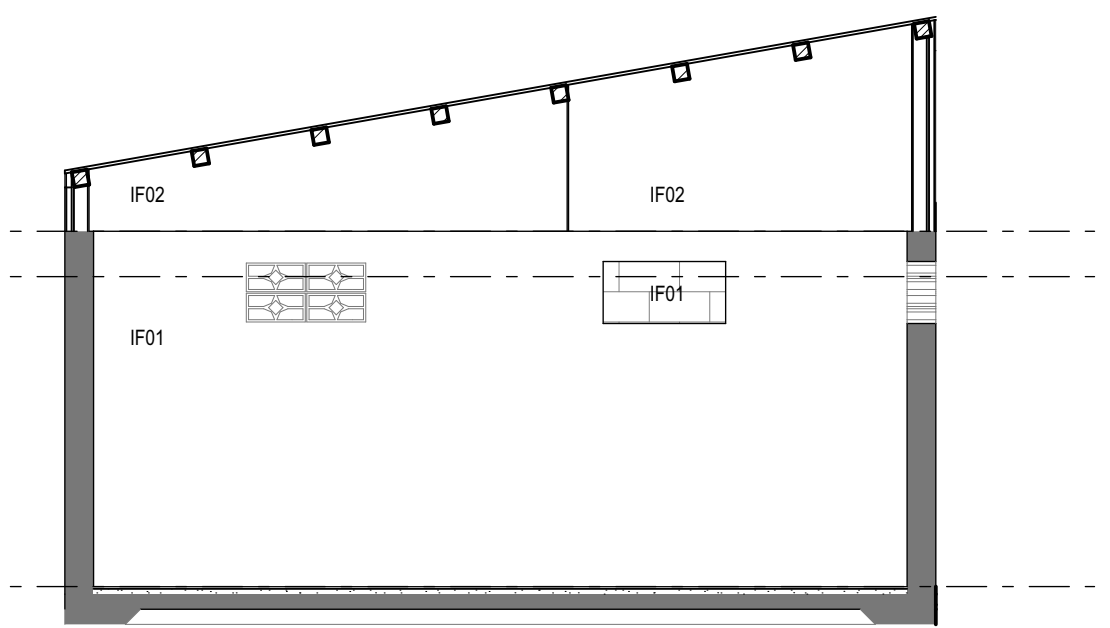


04 MALE AMENITIES
1:50

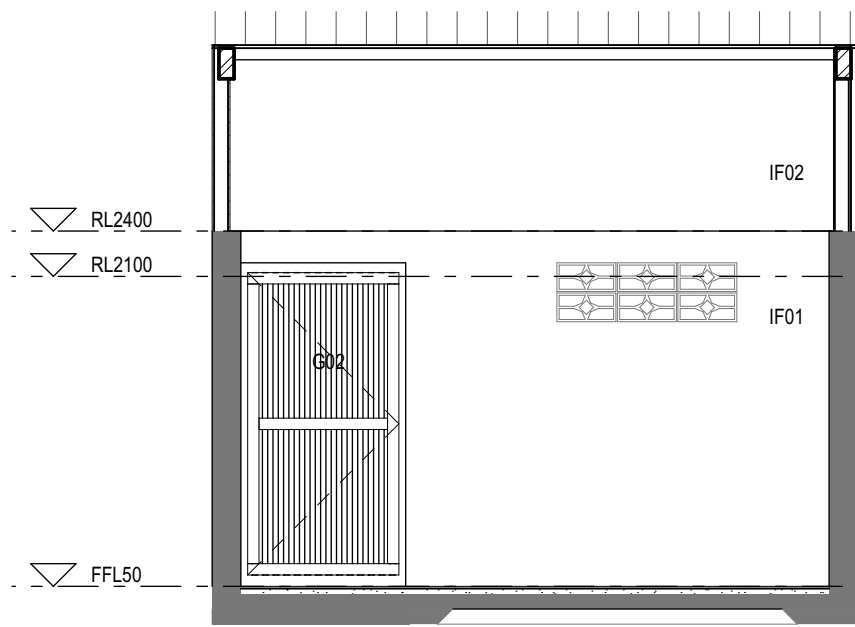


01 FEMALE AMENITIES
1:50

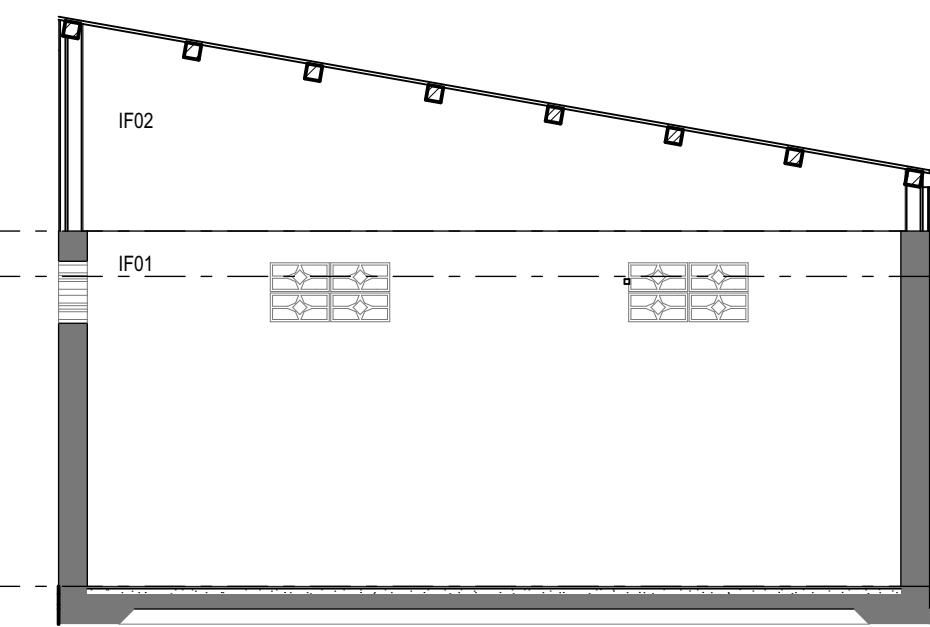


02 FEMALE AMENITIES
1:50

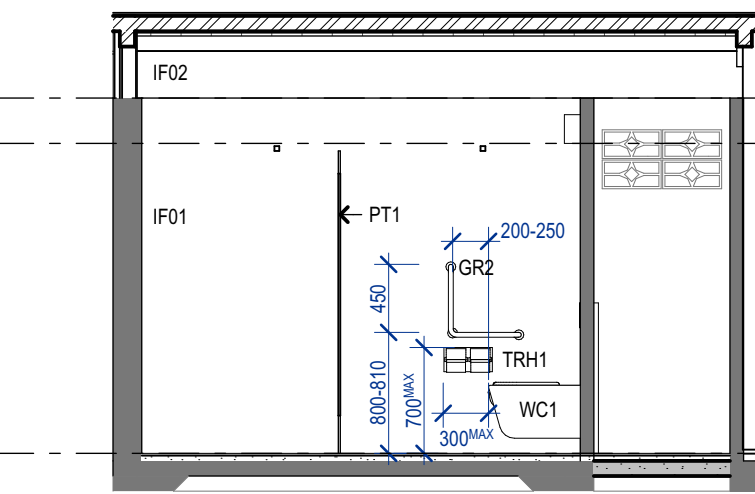


03 FEMALE AMENITIES
1:50

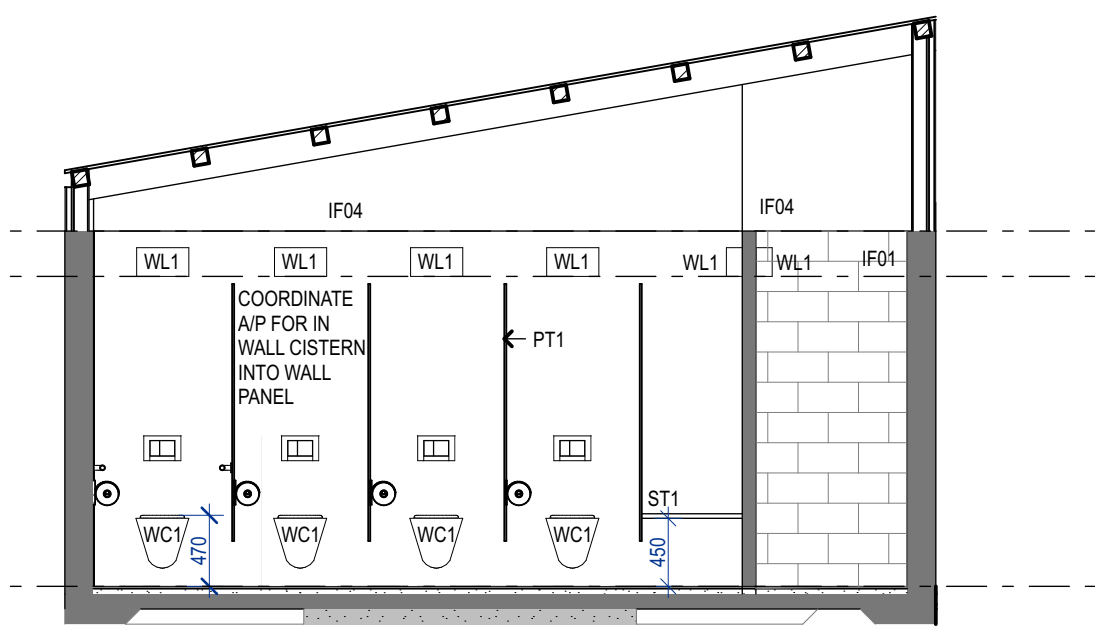


04 FEMALE AMENITIES
1:50

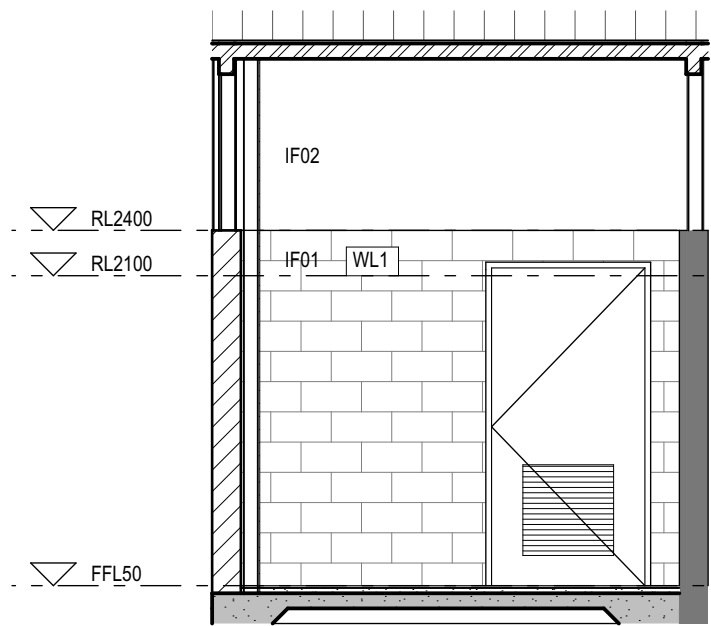


01 DDA AMENITIES
1:50

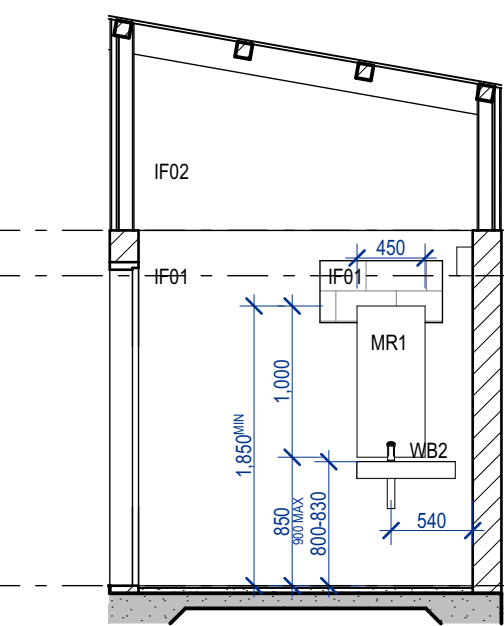

02 DDA AMENITIES
1:50

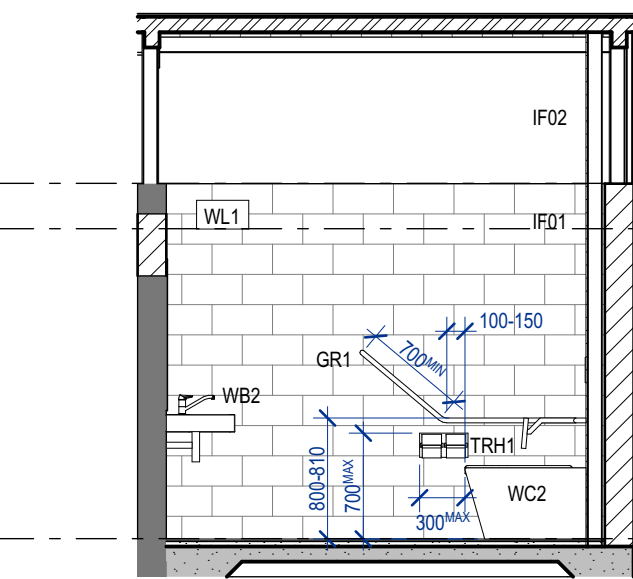

03 DDA AMENITIES
1:50

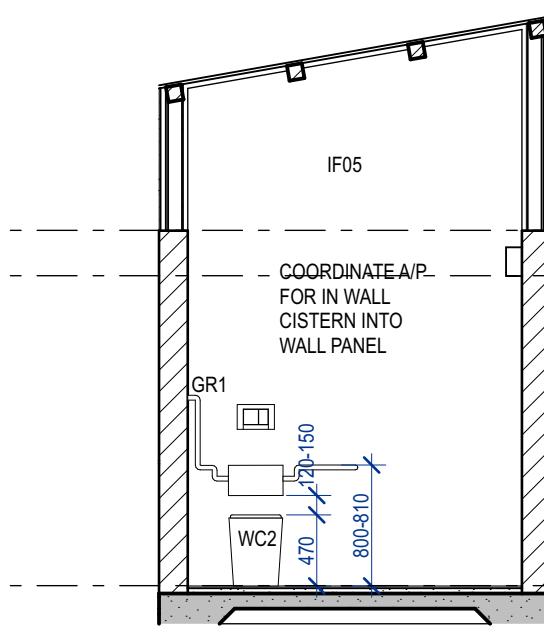

04 DDA AMENITIES
1:50

Issue ID	Issue Name	Issue Date
A	PRELIMINARY ISSUE	24/2/2026
B	BUILDING APPROVAL ISSUE	10/4/2026
01	CONSTRUCTION ISSUE	20/4/2026

Drawings to be read in conjunction with specification by TA and all drawings and documents by engineers and subconsultants referred to in these plans. Contractors are to verify all dimensions on site before commencing any work or producing shop drawings. Larger scale drawings and written dimensions take preference. Do not scale from drawings. These drawings are protected by the laws of copyright and may not be copied or reproduced without the written permission of TA. All discrepancies to be brought to the attention of the author. All building levels to AHD unless otherwise noted.

FOR CONSTRUCTION -
REV A

Project Name
ST HELENS MEMORIAL PARK
TOILET AMENITIES
Client
ST HELENS BREAK O'DAY COUNCIL
Project Address
39 CECILIA ST,
ST HELENS,
TAS 7216

INTERNALS -
WET AREA ELEVATIONS - SHEET 1

Scale: 1:50 @ A2
Status: FOR CONSTRUCTION
Checked By: STA
Date: 7/7/2026